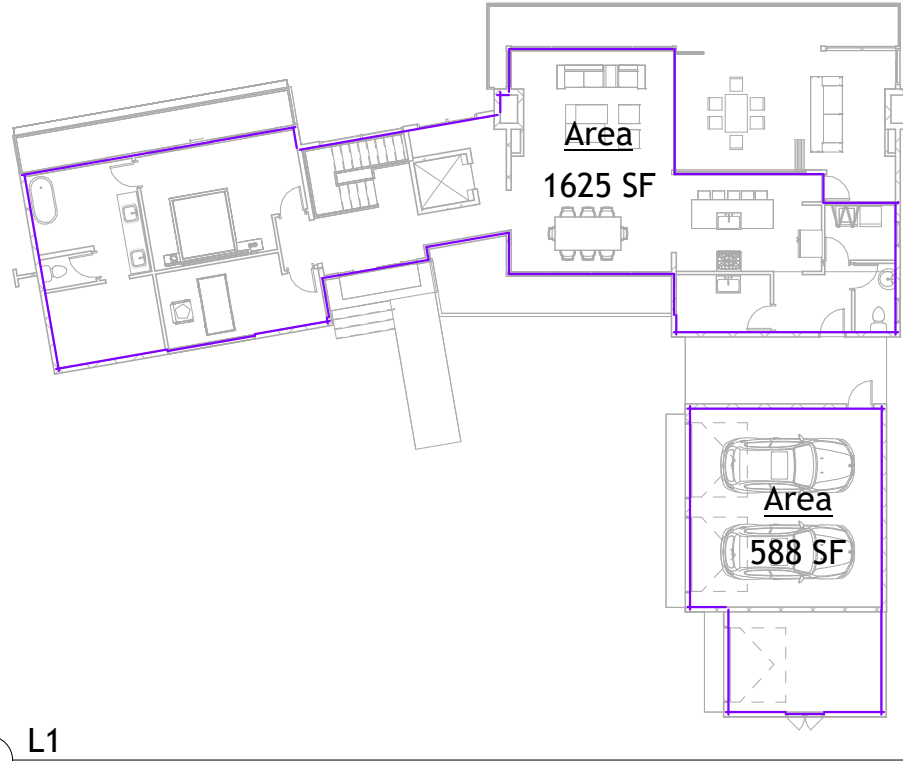
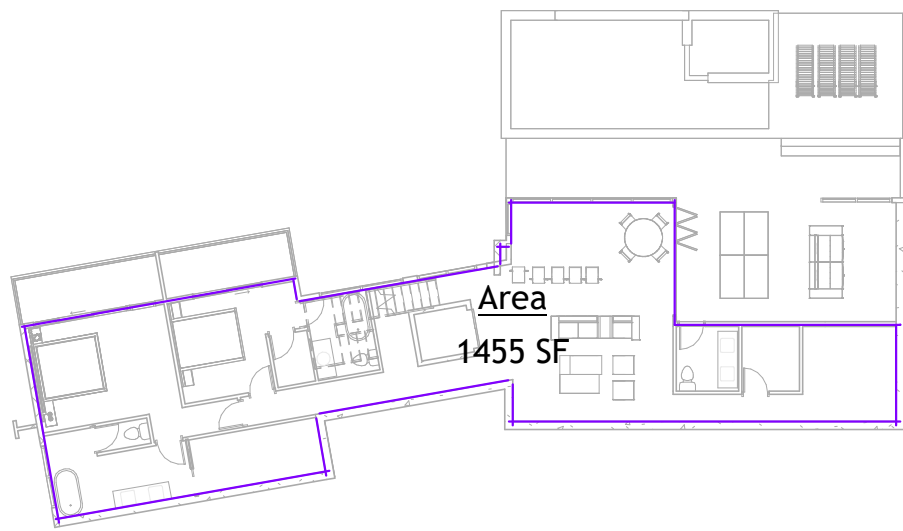
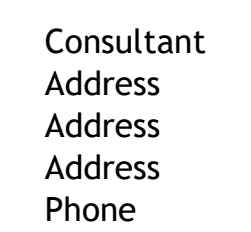


4631 Dunn Ln Angels Camp, Ca 95222.

NEW RESIDENTIAL CONSTRUCTION

GENERAL NOTES			3D VIEW																																																																				
SCOPE NEW CONSTRUCTION PARCEL APN ZONE OCCUPANCY	1. GENERAL NOTES APPLY TO ALL DRAWINGS 2. DO NOT SCALE DRAWINGS. ANY DIMENSIONAL INFORMATION REQUIRED WHICH IS NOT INDICATED ON DRAWING-DIMENSION STRINGS SHALL BE OBTAINED FROM THE ARCHITECT. 3. DIMENSIONS SHOWN ARE FINISH SURFACE OF EXISTING CONSTRUCTION, UNLESS NOTED OTHERWISE. 4. CONTRACTOR SHALL VERIFY ALL EXISTING DIMENSIONS AND CONDITIONS (I.E. EXISTING MATERIALS, FRAMING MEMBER SIZES AND LOCATIONS, METHODS OF CONSTRUCTION), IF DISCREPANCIES ARE FOUND, NOTIFY ARCHITECT BEFORE PROCEEDING WITH WORK. 5. CONTRACTOR SHALL PAY ALL PERMIT FEES. 6. CONTRACTOR SHALL MAINTAIN THE IMMEDIATE CONSTRUCTION SITE IN A SECURE, CLEAN AND SAFE MANNER, 7. PROTECTION: CONTRACTORS SHALL BE SOLELY RESPONSIBLE FOR TAKING ALL STEPS NECESSARY TO PROTECT THE PUBLIC FROM INJURY AND ADJACENT PROPERTY DAMAGES DURING CONSTRUCTION AS REQUIRED BY LOCAL CODES. 8. REPAIR ALL EXISTING CONSTRUCTION AFFECTED BY NEW WORK TO ITS ORIGINAL CONDITION																																																																						
	THIS PROJECT WILL COMPLY WITH THE FOLLOWING CODES 2022 California Building Code (CBC) 2022 California Residential Code (CRC) 2022 California Electrical Code (CEC) 2022 California Mechanical Code (CMC) 2022 California Plumbing Code (CPC) 2022 California Energy Code 2022 California Fire Code (CFC) 2022 California Green Building Standards Code.		VICINITY MAP 																																																																				
			Sheet Index <table><thead><tr><th>Sheet Number</th><th>Sheet Name</th></tr></thead><tbody><tr><td>A100A</td><td>GENERAL NOTE 1</td></tr><tr><td>A100B</td><td>GENERAL NOTE 2</td></tr><tr><td>A100C</td><td>GENERAL NOTE 3</td></tr><tr><td>General</td><td></td></tr><tr><td>G100</td><td>Cover</td></tr><tr><td>Civil</td><td></td></tr><tr><td>C101</td><td>Site Plan</td></tr><tr><td>Architectural</td><td></td></tr><tr><td>A101</td><td>Architectural Second floor Plans</td></tr><tr><td>A102</td><td>Architectural first Floor Plans</td></tr><tr><td>A103</td><td>ROOF PLAN</td></tr><tr><td>A201</td><td>Architectural Building Elevations</td></tr><tr><td>A202</td><td>Architectural Building Elevations</td></tr><tr><td>A301</td><td>Architectural Building Sections 1</td></tr><tr><td>A302</td><td>Architectural Building Sections 2</td></tr><tr><td>A501</td><td>Architectural Details 1</td></tr><tr><td>A502</td><td>Architectural Details 2</td></tr><tr><td>A503</td><td>Architectural Details 3</td></tr><tr><td>A601</td><td>Architectural Schedules</td></tr><tr><td>Plumbing</td><td></td></tr><tr><td>P100A</td><td>Plumbing Notes</td></tr><tr><td>P100B</td><td>Plumbing Details</td></tr><tr><td>P101</td><td>Plumbing Plans</td></tr><tr><td>P102</td><td>Plumbing Plans</td></tr><tr><td>Mechanical</td><td></td></tr><tr><td>M100A</td><td>Mechanical NOTES</td></tr><tr><td>M100B</td><td>Mechanical DETAILS</td></tr><tr><td>M101</td><td>Mechanical Plans</td></tr><tr><td>M102</td><td>Mechanical Plans</td></tr><tr><td>Electrical</td><td></td></tr><tr><td>E101</td><td>Power Plans</td></tr><tr><td>E102</td><td>Power Plans</td></tr></tbody></table>			Sheet Number	Sheet Name	A100A	GENERAL NOTE 1	A100B	GENERAL NOTE 2	A100C	GENERAL NOTE 3	General		G100	Cover	Civil		C101	Site Plan	Architectural		A101	Architectural Second floor Plans	A102	Architectural first Floor Plans	A103	ROOF PLAN	A201	Architectural Building Elevations	A202	Architectural Building Elevations	A301	Architectural Building Sections 1	A302	Architectural Building Sections 2	A501	Architectural Details 1	A502	Architectural Details 2	A503	Architectural Details 3	A601	Architectural Schedules	Plumbing		P100A	Plumbing Notes	P100B	Plumbing Details	P101	Plumbing Plans	P102	Plumbing Plans	Mechanical		M100A	Mechanical NOTES	M100B	Mechanical DETAILS	M101	Mechanical Plans	M102	Mechanical Plans	Electrical		E101	Power Plans	E102	Power Plans
	Sheet Number	Sheet Name																																																																					
A100A	GENERAL NOTE 1																																																																						
A100B	GENERAL NOTE 2																																																																						
A100C	GENERAL NOTE 3																																																																						
General																																																																							
G100	Cover																																																																						
Civil																																																																							
C101	Site Plan																																																																						
Architectural																																																																							
A101	Architectural Second floor Plans																																																																						
A102	Architectural first Floor Plans																																																																						
A103	ROOF PLAN																																																																						
A201	Architectural Building Elevations																																																																						
A202	Architectural Building Elevations																																																																						
A301	Architectural Building Sections 1																																																																						
A302	Architectural Building Sections 2																																																																						
A501	Architectural Details 1																																																																						
A502	Architectural Details 2																																																																						
A503	Architectural Details 3																																																																						
A601	Architectural Schedules																																																																						
Plumbing																																																																							
P100A	Plumbing Notes																																																																						
P100B	Plumbing Details																																																																						
P101	Plumbing Plans																																																																						
P102	Plumbing Plans																																																																						
Mechanical																																																																							
M100A	Mechanical NOTES																																																																						
M100B	Mechanical DETAILS																																																																						
M101	Mechanical Plans																																																																						
M102	Mechanical Plans																																																																						
Electrical																																																																							
E101	Power Plans																																																																						
E102	Power Plans																																																																						
		AREA PLAN LOT AREA = ~ 42.95 ACRES FLOOR LIVING AREA : 3075 SQ.FT. GARAGE AREA: 588 SQ.FT. MAX STRUCTURE HEIGHT: 19.25 FT.  ② L1 1" = 20'-0"  ③ L0 1" = 20'-0"																																																																					
Consultant Address Address Address Address Phone			Project Number Date Project Number Issue Date 																																																																				

[illegible]

NEW RESIDENTIAL CONSTRUCTION

Project Number	Project Number
Date	Issue Date
Drawn By	Author
Checked By	Checker

Scale	1/8" = 1'-0"
-------	--------------

6/2/2025 2:47:47 PM



A.F.F. ABOVE
A.F.F. ABOVE FINISHED FLOOR
ADJ. ADJUSTABLE
A/C AIR CONDITIONING
ALC. ALTERNATE
ALUM. ALUMINUM
A.B. ANCHOR BOLT
A.C.T. ARCHITECTURAL JOINT
ARCH. ARCHITECT (URAL)
ASPH. ASPHALT
BRG. BEARING
BM. BEAM
B.M. BENCH MARK
BEL. BELOW
BET. BETWEEN
BLK. BLOCK
BLCKG. BLOCKING
BD. BOARD
B.S. BOTH SIDES
B.W. BOTH WAYS
BOT. BOTTOM
B.T.O.B. BOTTOM OF BEAM
BLDG. BUILDING
CAB. CABINET
CSMT. CASEMENT
C.I. CAST IRON
CATCH. BASIN
CLG. CEILING
CEM. CEMENT
CPPL. CEMENT PLASTER (PORTLAND)
C.T. CER. CERAMIC TILE
CIRC. CIRCLE
CIRCUMFERENCE
CLR. CLEAR
COL. COLUMN
COMBINATION
CONC. CONCRETE
C.M.U. CONCRETE MASONRY UNIT
CONST. CONSTRUCTION
CONT. CONTINUOUS OR CONTINUE
CONTR. CONTRACTOR
C.J. CONTROL JOINT
COPPER
CNTR. COUNTER
CPL. COUNTERFLASHING
COUNTERSINK
COUNTERSINK SCREW
DMPR. DAMPER
DP. DAMPROOFING
D.L. DEAD LOAD
DEEP
DTL., DET. DETAIL
DIAG. DIAGONAL
DIA. DIAMETER
DIM. DIMENSION
DIV. DIVISION
DR. DOOR
D.H. DOUBLE HUNG
D.S. DOWNSPOUT
DISP. DISPENSER
D. DRAIN
DRAW. DRAWER
DWRG. DRAWING
EAST
ELEC. ELECTRICAL (AL)
EL., ELEV. ELEVATION
ELEV. ELEVATOR
EXIST. EXISTING
E.P.S. EXFENDED POLYSTYRENE BOARD
EQ. EQUAL
E.R. EMERGENCY
EX. EXHAUST
E.I.F.S. EXTERIOR INSULATING FINISH SYSTEM
F.C. FACE OF CONCRETE
F.O.F. FACE OF FINISH
F.O.M. FACE OF MASONRY
FOS. FACE OF STUDS OR STEEL
FIN. FINISH (ED)
FINISH FLOOR ELEVATION
FBRK. FIRE BRICK
F.P. FIREPLACE
FLR. FLOOR (ING)
F.O.D. FLOOR DRAIN
FLUORESCENT
FR.F.R.P. FIBERGLASS REINFORCED PANEL
FTG. FOOTING
G.C. GAUGE, GAUGE
GALV. GALVANIZED IRON
G.A. GENERAL CATALOG (OR)
GL. GLASS
G.W.B. GYPSUM WALL BOARD
GYP. GYPSUM
HDWE. HARDWARE
HRWD. HARDWOOD
HDR. HEADER
HVAC. HEATING/VENTILATING/AIR CONDITIONING
H.D. HEAT DUTY
HGT., HT. HEIGHT
H. HI. HIGH
H.C. HOLLOW CORE
H.C. HANDICAPPED
H.O.L.W. METAL
H.B. HOSE BIBB
INCL. INCLUDE (D), (ING)
I.D. INSIDE DIAMETER
INSUL. INSULATION, INSULATING
INT. INTERIOR
LAM. LAMINATE (D)
LAV. LAVATORY
L.H. LEFT HAND
L.H. LENGTH, LONG
MSRY. MASONRY
MAX. MAXIMUM
MECH. MECHANIC (AL)
M.C. MEDICINE CABINET
MED. MEDICINE
MEMB. MEMBER
MEMB. MEMBRANE
MTL. METAL
M. METER (S)
MIN. MINIMUM
MIR. MIRROR
MISC. MISCELLANEOUS
N. NORTH
N.I.C. NOT IN CONTRACT
N.T.S. NOT TO SCALE
O.C. ON CENTER (S)
OPNG. OPENING
OPP. OPPOSITE
OPP. HAND. OPPOSITE HAND
O.D. OVERFLOW DRAIN
P.D. PAINTED

Diagram illustrating the components of a door schedule symbol:

- DOOR NUMBER**: Indicated by a circle containing "5A".
- WINDOW NUMBER**: Indicated by a circle containing "WA".
- ELEVATION MARK - HEIGHT ABOVE REF. ELEV. (0'-0")**: Indicated by a triangle containing "1".
- REVISION NUMBER**: Indicated by a circle containing "3".
- SECTION NUMBER**: Indicated by a circle containing "A500".
- SHEET NUMBER**: Indicated by a circle containing "101".
- ROOM NUMBER**: Indicated by a circle containing "101".
- INTERIOR ELEVATION NUMBER**: Indicated by a triangle containing "1/A700".
- SHEET NUMBER**: Indicated by a circle containing "5".
- DETAIL NUMBER**: Indicated by a circle containing "A900".
- SHEET NUMBER**: Indicated by a circle containing "1".
- EXTERIOR ELEVATION NUMBER**: Indicated by a triangle containing "A400".
- SHEET NUMBER**: Indicated by a circle containing "1".

ALL WORK SHALL BE PERFORMED IN ACCORDANCE WITH ALL APPLICABLE CODES, REGULATIONS, ORDINANCES AND STANDARDS, HAVING JURISDICTION, INCLUDING APPLICABLE TEXAS LAW AND AMERICANS WITH DISABILITIES ACT. IF THERE ARE ANY QUESTIONS OR CONFLICTS CONCERNING COMPLIANCE WITH SUCH CODES, ORDINANCES OR STANDARDS, THE CONTRACTOR IS RESPONSIBLE FOR NOTIFYING THE ARCHITECT BEFORE PROCEEDING WITH THE WORK IN QUESTION. ALL NECESSARY LICENSES, CERTIFICATES, TESTS, ETC. SHALL BE PROCURED AND PAID FOR BY THE CONTRACTOR. ALL NECESSARY PERMITS SHALL BE PROCURED BY THE CONTRACTOR AND PAID FOR BY OWNER.

CONTRACTOR IS RESPONSIBLE FOR CHECKING ALL CONTRACT DOCUMENTS, FIELD CONDITIONS AND DIMENSIONS FOR ACCURACY AND CONFIRMING THAT THE WORK IS BUILDABLE AS SHOWN AND MEETS ALL APPLICABLE CODES BEFORE PROCEEDING WITH CONSTRUCTION. IF THERE ARE ANY QUESTIONS REGARDING THESE OR OTHER COORDINATION ISSUES, THE CONTRACTOR IS RESPONSIBLE FOR OBTAINING A CLARIFICATION FROM THE ARCHITECT BEFORE PROCEEDING WITH THE WORK IN QUESTION OR RELATED WORK.

THE CONTRACTOR SHALL CERTIFY SIZE AND LOCATION OF ALL REQUIRED OPENINGS FOR STRUCTURAL, MECHANICAL, ELECTRICAL AND PLUMBING WORK AND EQUIPMENT WITH TRADES INVOLVED.

THE GENERAL CONTRACTOR AND EACH SUBCONTRACTOR SHALL BE RESPONSIBLE FOR CHECKING EXISTING CONDITIONS AT THE JOB SITE BEFORE SUBMITTING PROPOSALS. SUBMISSION OF PROPOSALS SHALL BE TAKEN AS EVIDENCE THAT SUCH INSPECTIONS HAVE BEEN MADE. CLAIMS FOR EXTRA COMPENSATION FOR WORK THAT COULD HAVE BEEN FORESEEN BY SUCH INSPECTION, WHETHER SHOWN ON CONTRACT DOCUMENTS OR NOT, SHALL NOT BE ACCEPTED OR PAID.

ALL MATERIALS FURNISHED UNDER THIS CONTRACT SHALL BE NEW UNLESS NOTED OTHERWISE. ALL WORK SHALL BE GUARANTEED AGAINST DEFECTIVE MATERIALS AND WORKMANSHIP FOR A PERIOD OF ONE (1) YEAR AFTER THE DATE OF SUBSTANTIAL COMPLETION OR ACCEPTANCE OF THE WORK. THE CONTRACTOR SHALL REPAIR OR REPLACE, AT HIS OWN EXPENSE WHEN ORDERED TO DO SO, ALL WORK THAT MAY DEVELOP DEFECTS IN MATERIAL OR WORKMANSHIP WITHIN THE ONE YEAR TIME PERIOD.

ALL EQUIPMENT SHALL BE INSTALLED IN ACCORDANCE WITH MANUFACTURERS' PUBLISHED RECOMMENDATIONS FOR SERVICE INTENDED, AS INTERPRETED BY THE ENGINEER AND ARCHITECT. THE INSTALLATION OF ALL EQUIPMENT SHALL BE MADE BY EXPERIENCED CRAFTSMEN IN A NEAT, WORKMANLIKE MANNER. ALL MATERIALS, TOOLS, COSTS AND SERVICES NECESSARY TO COMPLETELY INSTALL ALL MECHANICAL, ELECTRICAL AND PLUMBING WORK SHALL BE PROVIDED BY THE CONTRACTOR.

CONTRACTOR SHALL BE RESPONSIBLE FOR ADEQUATELY BRACING AND PROTECTING ALL WORK DURING CONSTRUCTION AGAINST DAMAGE, BREAKAGE, COLLAPSE AND MISALIGNMENT ACCORDING TO APPLICABLE CODES, STANDARDS AND GOOD CONSTRUCTION PRACTICES. CONTRACTOR SHALL TAKE PROPER PRECAUTIONS TO PROTECT ALL EXISTING STRUCTURES AND PROPERTY ADJACENT TO WHICH HIS WORK COMES IN CONTACT, OR OVER OR UNDER WHICH HE MAY TRANSPORT, HOST OR MOVE MATERIALS, EQUIPMENT, DEBRIS, ETC., AND SHALL REPAIR SATISFACTORILY ALL DAMAGES CAUSED BY HIM DURING CONSTRUCTION.

THE CONTRACTOR SHALL VERIFY AND COORDINATE SIZES, LOCATIONS AND CHARACTERISTICS OF ALL WORK AND EQUIPMENT TO BE FURNISHED BY THE OWNER, OR OTHERS WITH THE MANUFACTURER OR SUPPLIER BEFORE ANY CONSTRUCTION IS BEGIN.

THE CONTRACTOR SHALL SUBMIT TO THE OWNER CONFIRMATIONS OF ORDERS, INCLUDING DELIVERY DATES FOR ALL MATERIALS AND EQUIPMENT WHOSE TIMELY DELIVERY IS REQUIRED TO AVOID CHANGES IN THE CONSTRUCTION DOCUMENTS OR IN THE CONSTRUCTION DOCUMENTS OR IN THE CONSTRUCTION SCHEDULE.

THE CONTRACTOR SHALL SUBMIT SHOP DRAWINGS TO THE ARCHITECT FOR APPROVAL BEFORE PROCEEDING WITH FABRICATIONS. THE CONTRACTOR REMAINS RESPONSIBLE FOR DETAILS AND ACCURACY FOR CONFIRMING AND CORRELATING ALL QUANTITIES AND DIMENSIONS, FOR SELECTING FABRICATION PROCESSES, FOR TECHNIQUES OR ASSEMBLY, FOR PERFORMING THE WORK IN A SAFE MANNER, AND FOR ADHERING TO ALL APPLICABLE CODES AND STANDARDS.

ALL MEP RELATED ITEMS SHOULD BE REVIEWED BY THE ENGINEER AND MAY BE ADJUSTED PENDING NOTICE TO AND APPROVAL OF THE ARCHITECT.

WRITTEN DIMENSIONS SHALL HAVE PRECEDENCE OVER SCALED DIMENSIONS.

ALL WORK NOTED "U/C" OR "NOT IN CONTRACT" IS TO BE ACCOMPLISHED BY A CONTRACTOR OTHER THAN THE GENERAL CONTRACTOR AND IS NOT TO BE PART OF THE CONSTRUCTION AGREEMENT.

"ALIGN" AS USED IN THESE DOCUMENTS SHALL MEAN TO ACCURATELY LOCATE FINISH FACES IN THE SAME PLANE.

"TYPICAL" OR "TYP" AS USED IN THESE DOCUMENTS SHALL MEAN THAT THE CONDITIONS IS THE SAME OR REPRESENTATIVE FOR ALL SIMILAR CONDITIONS THROUGHOUT, UNLESS NOTED OTHERWISE.

"SIMILAR" OR "SIM" AS USED IN THESE DOCUMENTS SHALL MEAN THAT THE CONDITION IS SIMILAR TO A CONDITION DETAILED FOR ANOTHER LOCATION.

THE COVER SHEET IS A MASTER INDEX. NOT ALL SYMBOLS/ITEMS WILL BE INCLUDED IN DRAWINGS.

DO NOT DISASSEMBLE THIS SET. COVER SHEET CONTAINS DATA PERTINENT TO ALL SHEETS.

GENERAL CONTRACTOR SHALL BE RESPONSIBLE FOR MAINTAINING A CLEAN JOBSITE, INCLUDING WATERING AS REQUIRED TO CONTROL DUST. AT COMPLETION OF CONSTRUCTION, THOROUGHLY CLEAN SITE AND ALL CONSTRUCTION AREAS.



	Consultant
	Address
	Address
	Address
	Phone

Consultant
Address
Address
Address
Phone

Consultant
Address
Address
Address
Phone

Consultant

Address

Address

Address

Phone

Consultant
Address
Address
Address
Phone


[illegible]

4631 Dunn Ln
Angels Camp, Ca
95222.


NEW RESIDENTIAL CONSTRUCTION

GENERAL NOTE 1

Project Number	Project Number
Date	Issue Date
Drawn By	Author
Checked By	Checker
A100A	
Scale	1/8" = 1'-0"

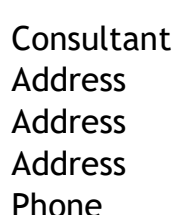


A100C
Scale

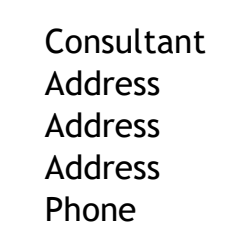[illegible]


Architectural Second floor Plans

A101	
Scale	$1/4" = 1'-0"$

WALL SCHEDULE		
S/N	CODE	DESCRIPTION
1	G01	2 x 4" INTERIOR STUD WALL.
2	G02	2 x 6" INTERIOR STUD WALL.
3	G04	2 x 6" EXTERIOR STUD WALL.
4	G05	2 x 6" EXTERIOR STUD WALL W/ EXT STONE CLADDING
5	G08	2 x 8" STONE WALL 2HR FIRE RATING
6	C02	6" CONCRETE WALL
7	C03	2 x 10" FOUNDATION WALL

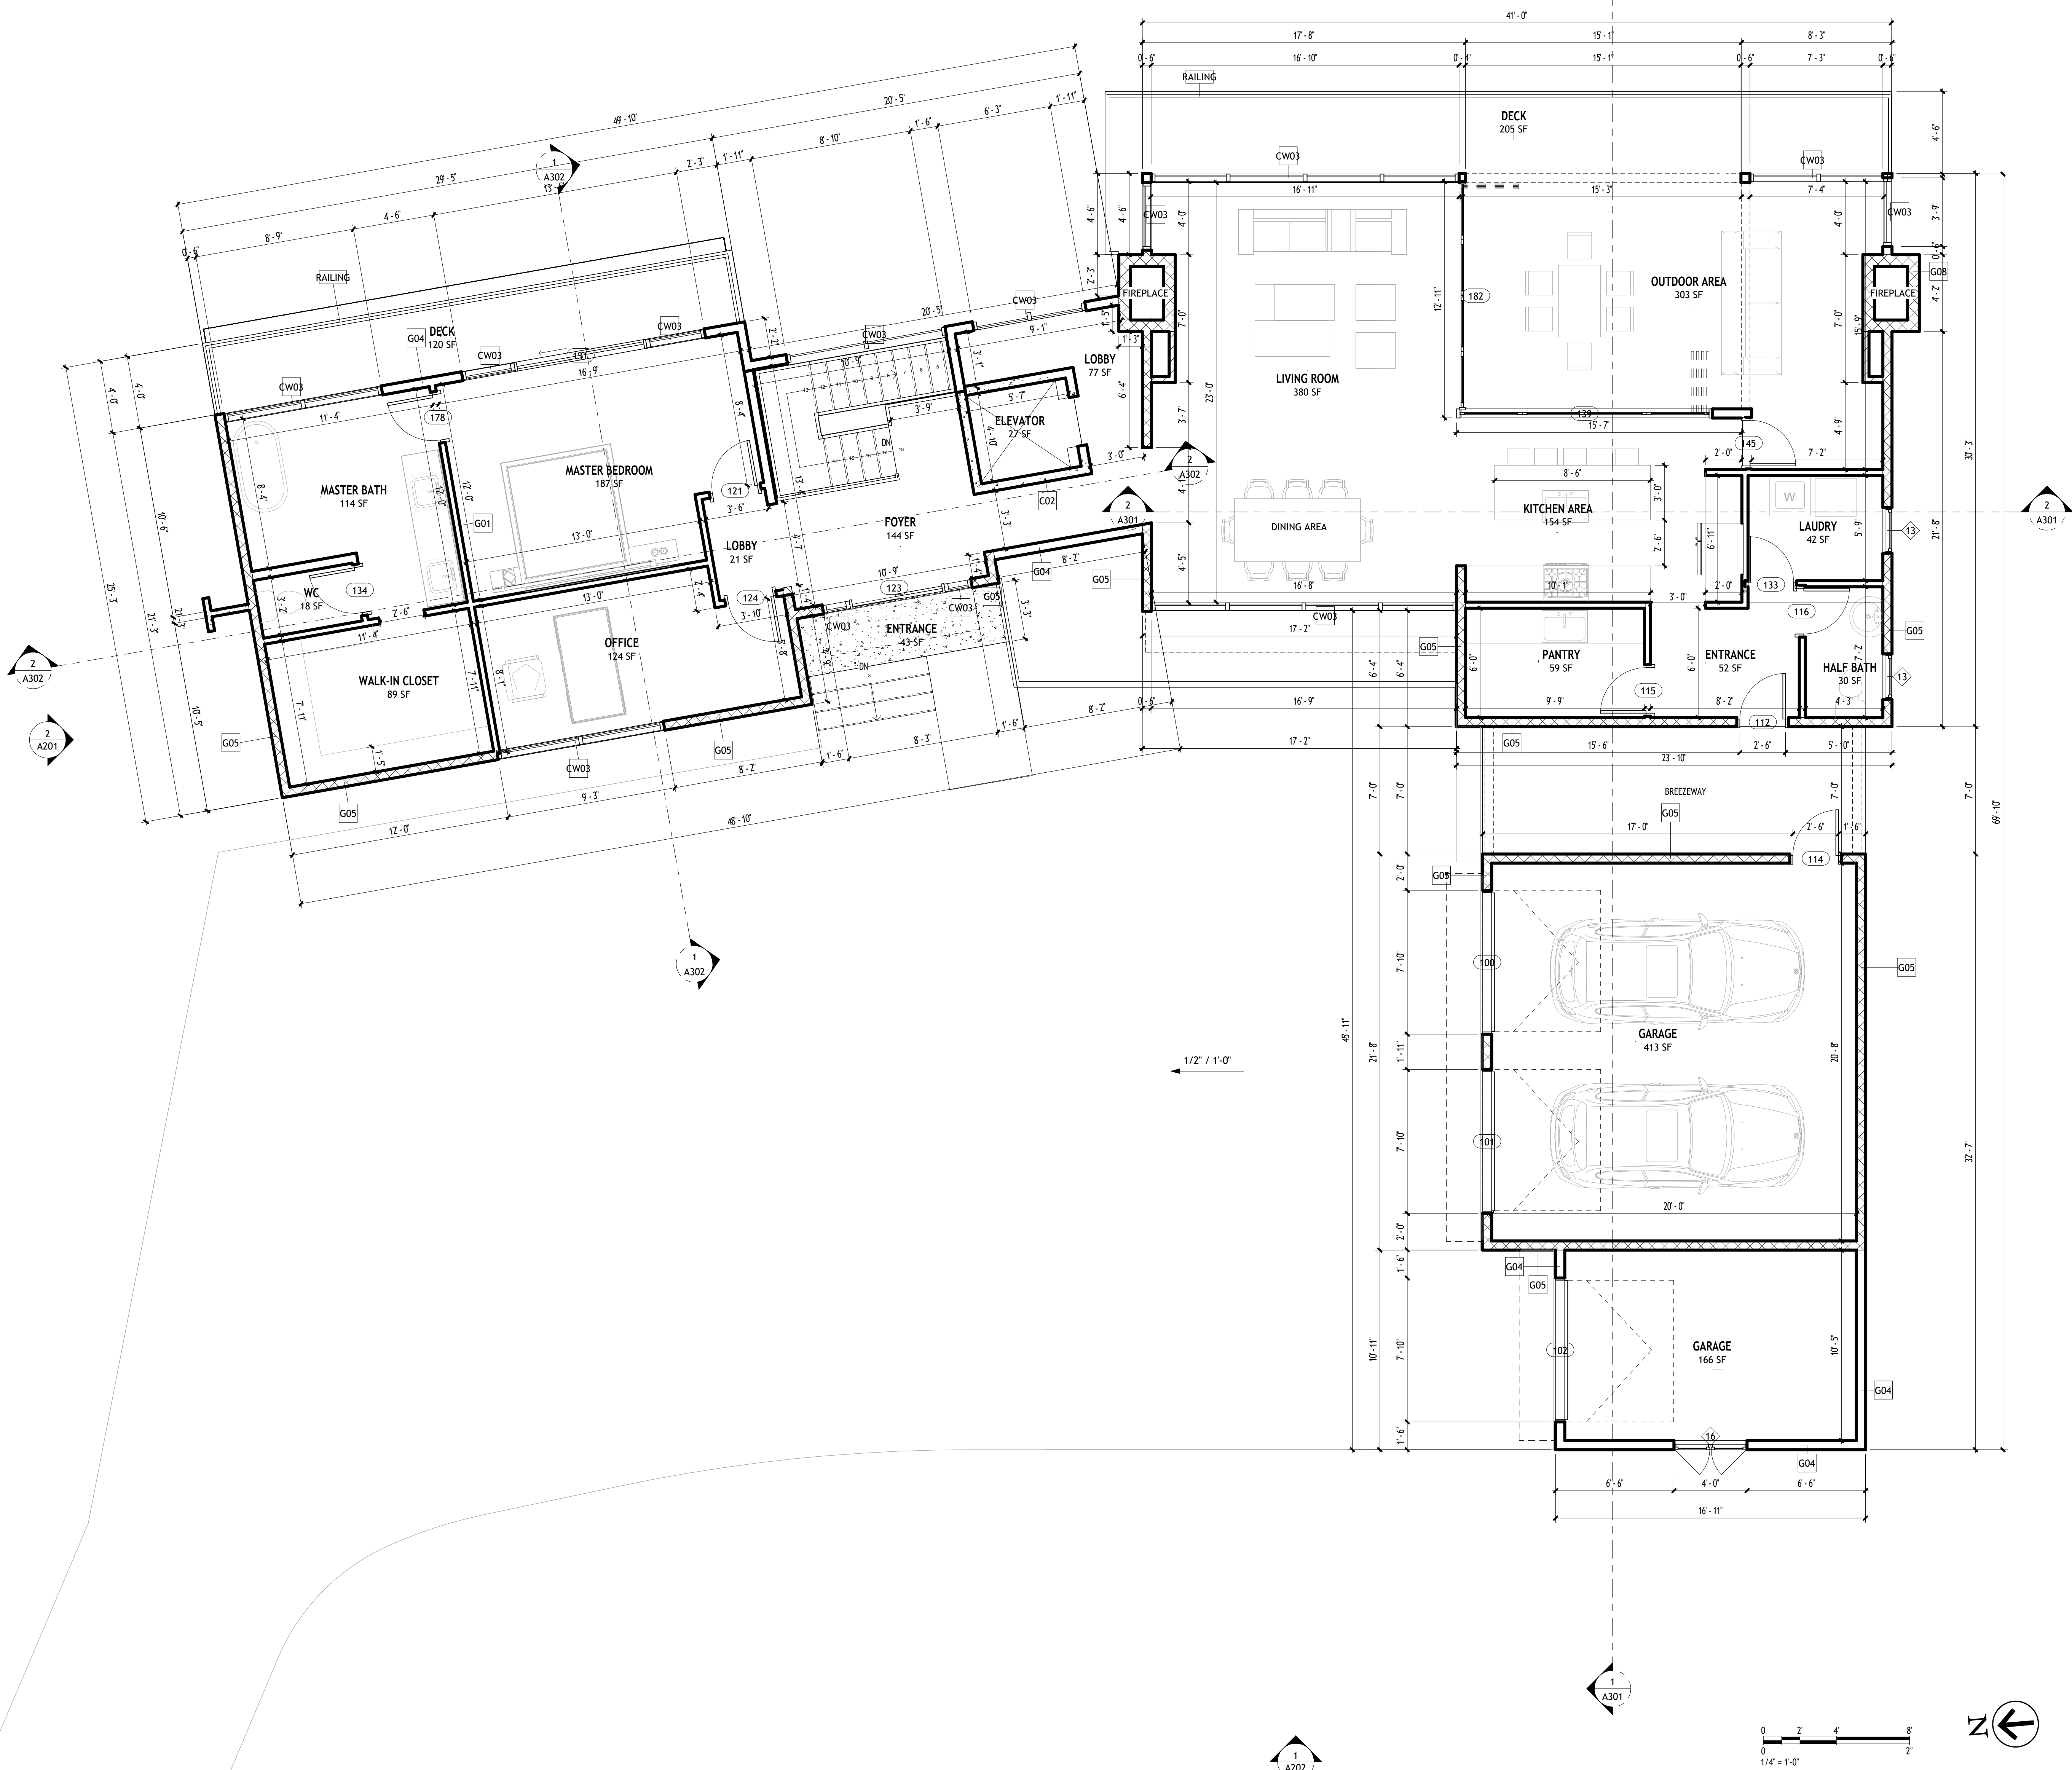

1 First Floor Architectural Plan
1/4" = 1'-0"

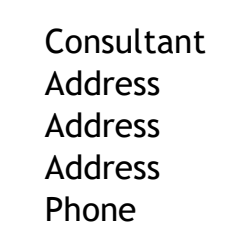[illegible]

Architectural first Floor Plans

Project Number	Project Number
Date	Issue Date
Drawn By	Author
Checked By	Checker

Scale $1/4" = 1'-0"$

S/N	CODE	DESCRIPTION
1	G01	2 x 4" INTERIOR STUD WALL.
2	G02	2 x 6" INTERIOR STUD WALL.
3	G04	2 x 6" EXTERIOR STUD WALL.
4	G05	2 x 6" EXTERIOR STUD WALL W/ EXT STONE CLADDING
5	G08	2 x 8" STONE WALL 2HR FIRE RATING
6	C02	6" CONCRET WALL
7	C03	2 x 10" FOUNDATION WALL



Consultant
Address
Address
Address
Phone

Consultant

Address

Address

Address

Phone

	Consultant
	Address
	Address
	Address
	Phone

Consultant
Address
Address
Address
Phone

Consultant
Address
Address
Address
Phone


[illegible]




4631 Dunn Ln
Angels Camp, Ca
95222.

NEW RESIDENTIAL CONSTRUCTION



ROOF PLAN

Project Number	Project Number
Date	Issue Date
Drawn By	Author
Checked By	Checker
A103	
Scale	1/4" = 1'-0"

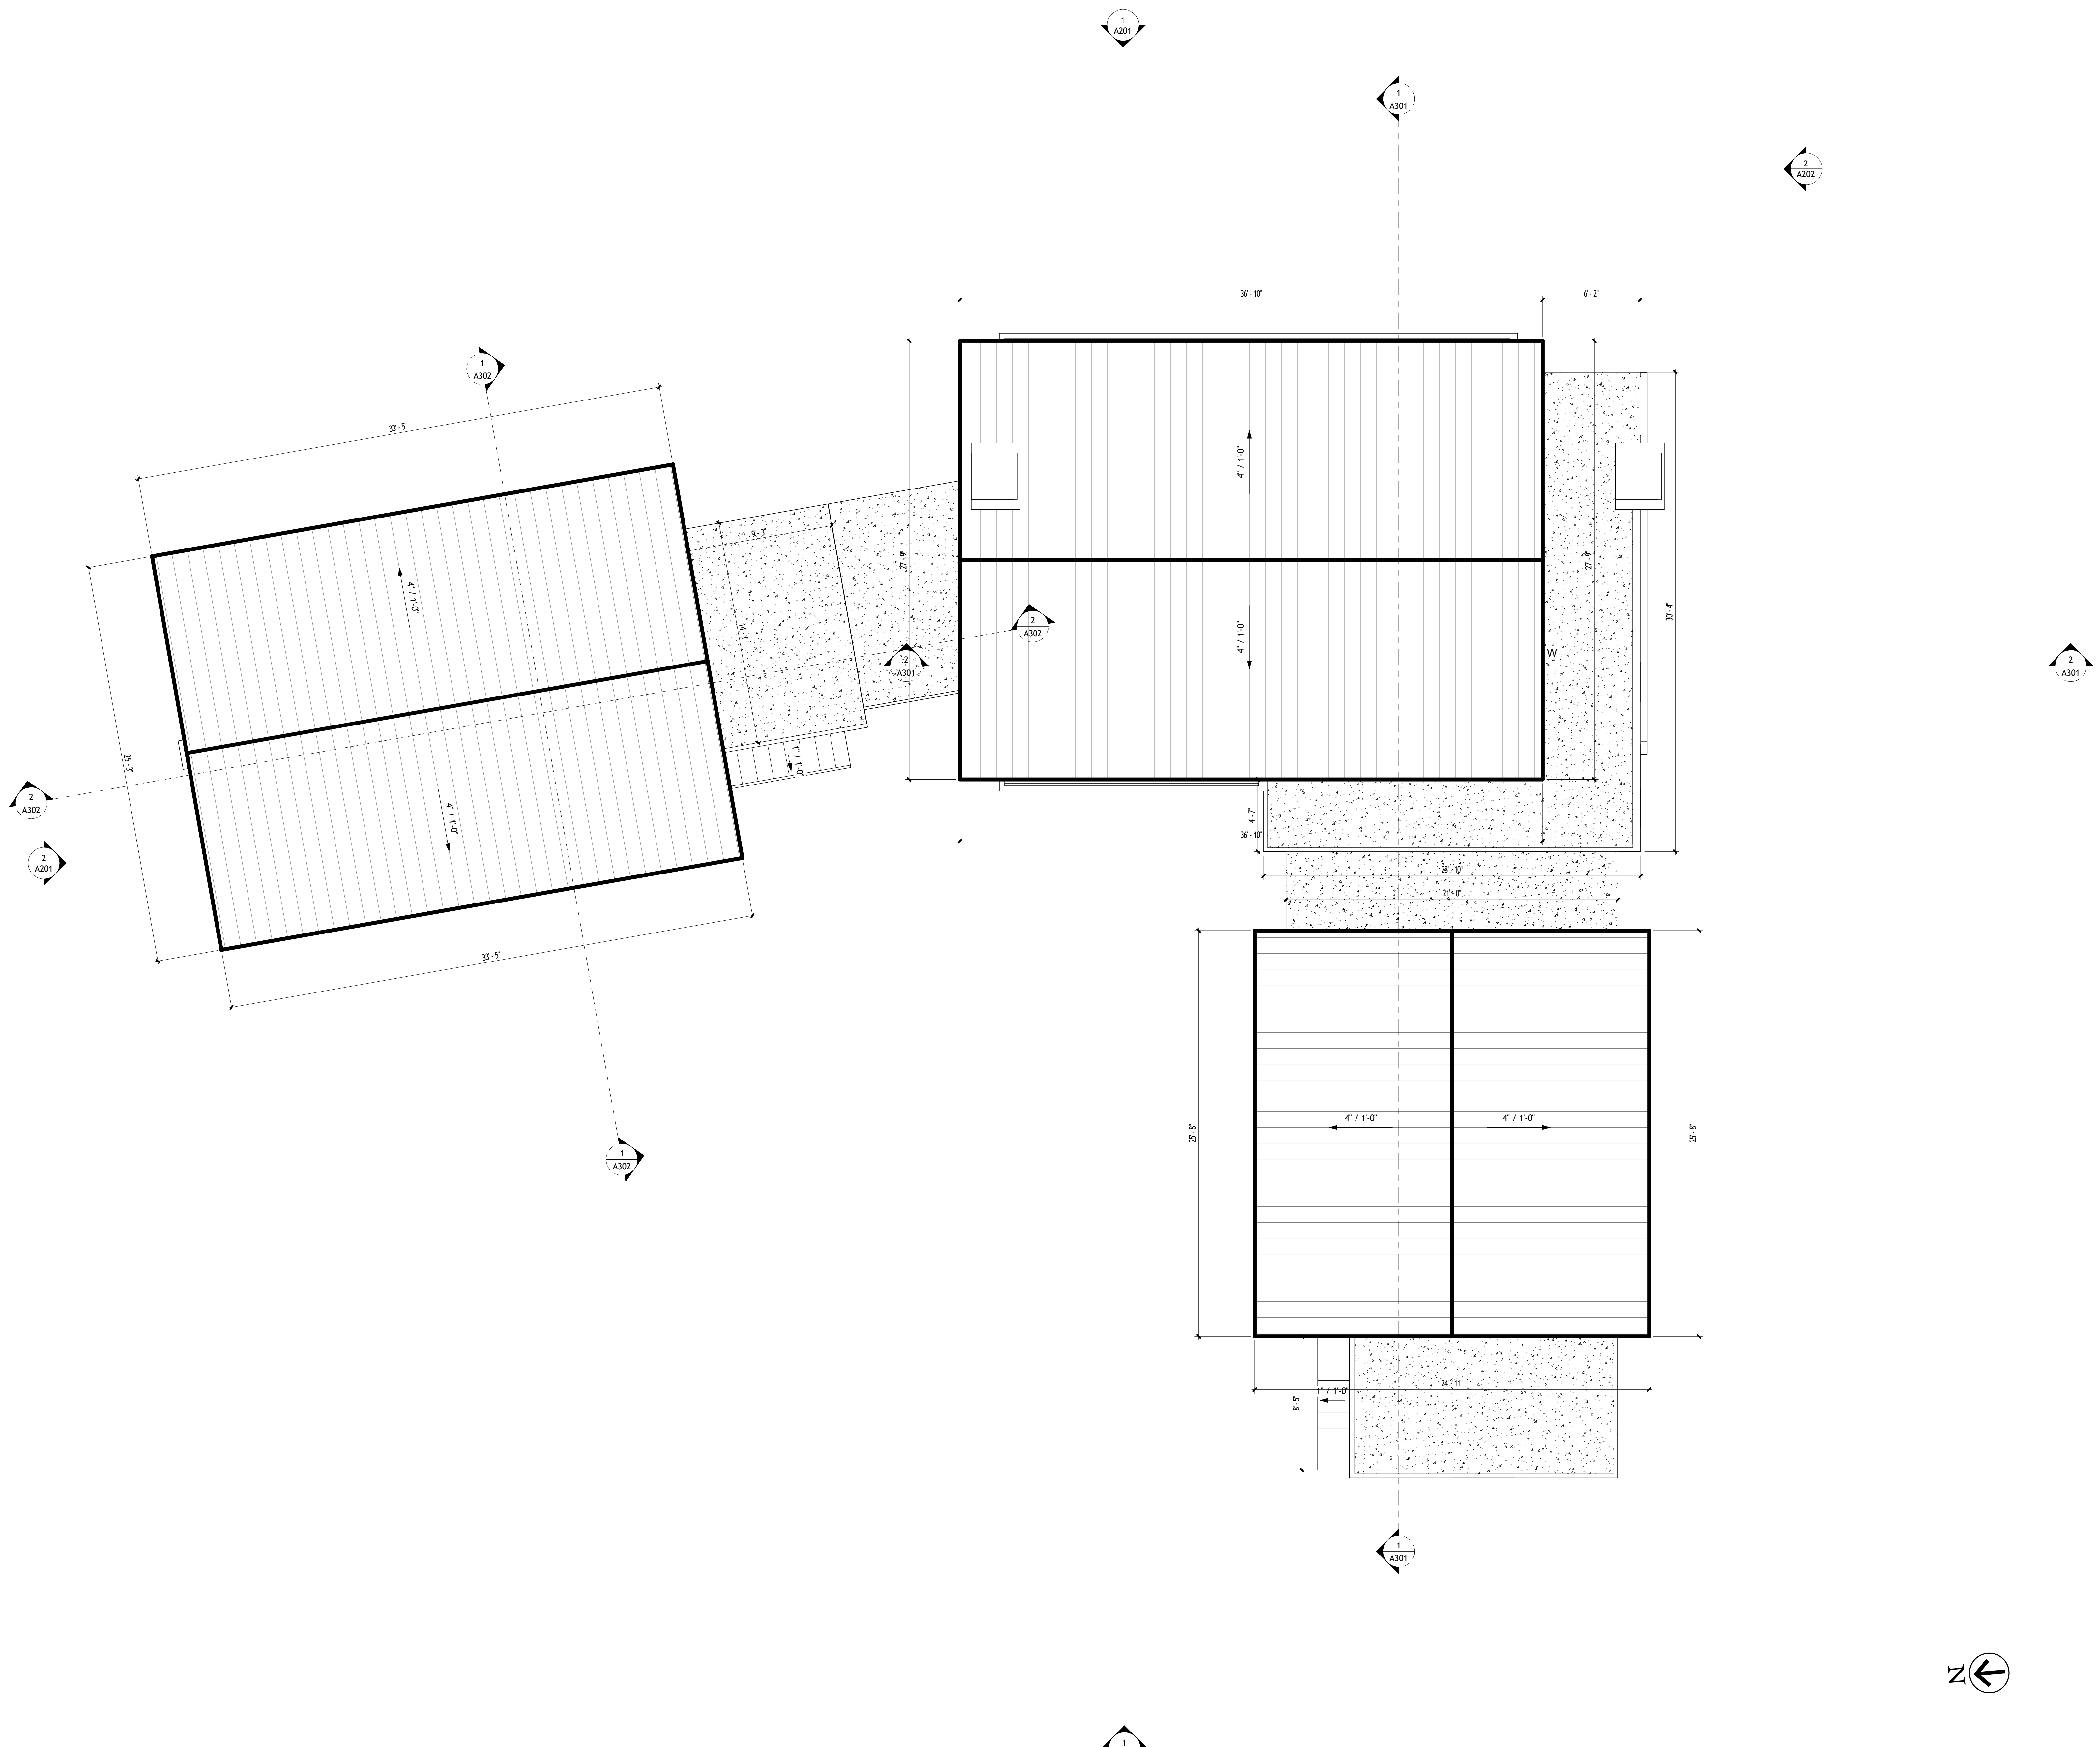

 
 
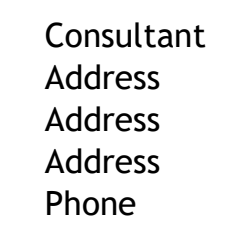


A201	
Scale	1/4" = 1'-0"

 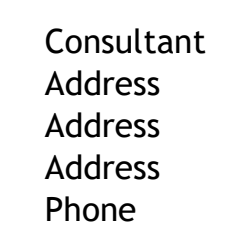


Project Number	Project Number
Date	Issue Date
Drawn By	Author
Checked By	Checker
	
Scale	1/4" = 1'-0"



  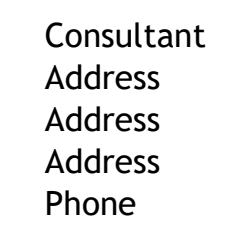


Project Number	Project Number
Date	Issue Date
Drawn By	Author
Checked By	Checker
	
Scale	1/4" = 1'-0"

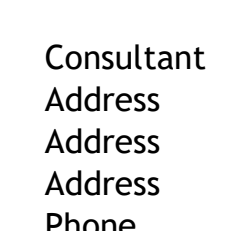[illegible]


Architectural Building Sections 2

Object Number	Project Number
ate	Issue Date
rawn By	Author
hecked By	Checker

scale	$1/4" = 1'-0"$
-------	----------------

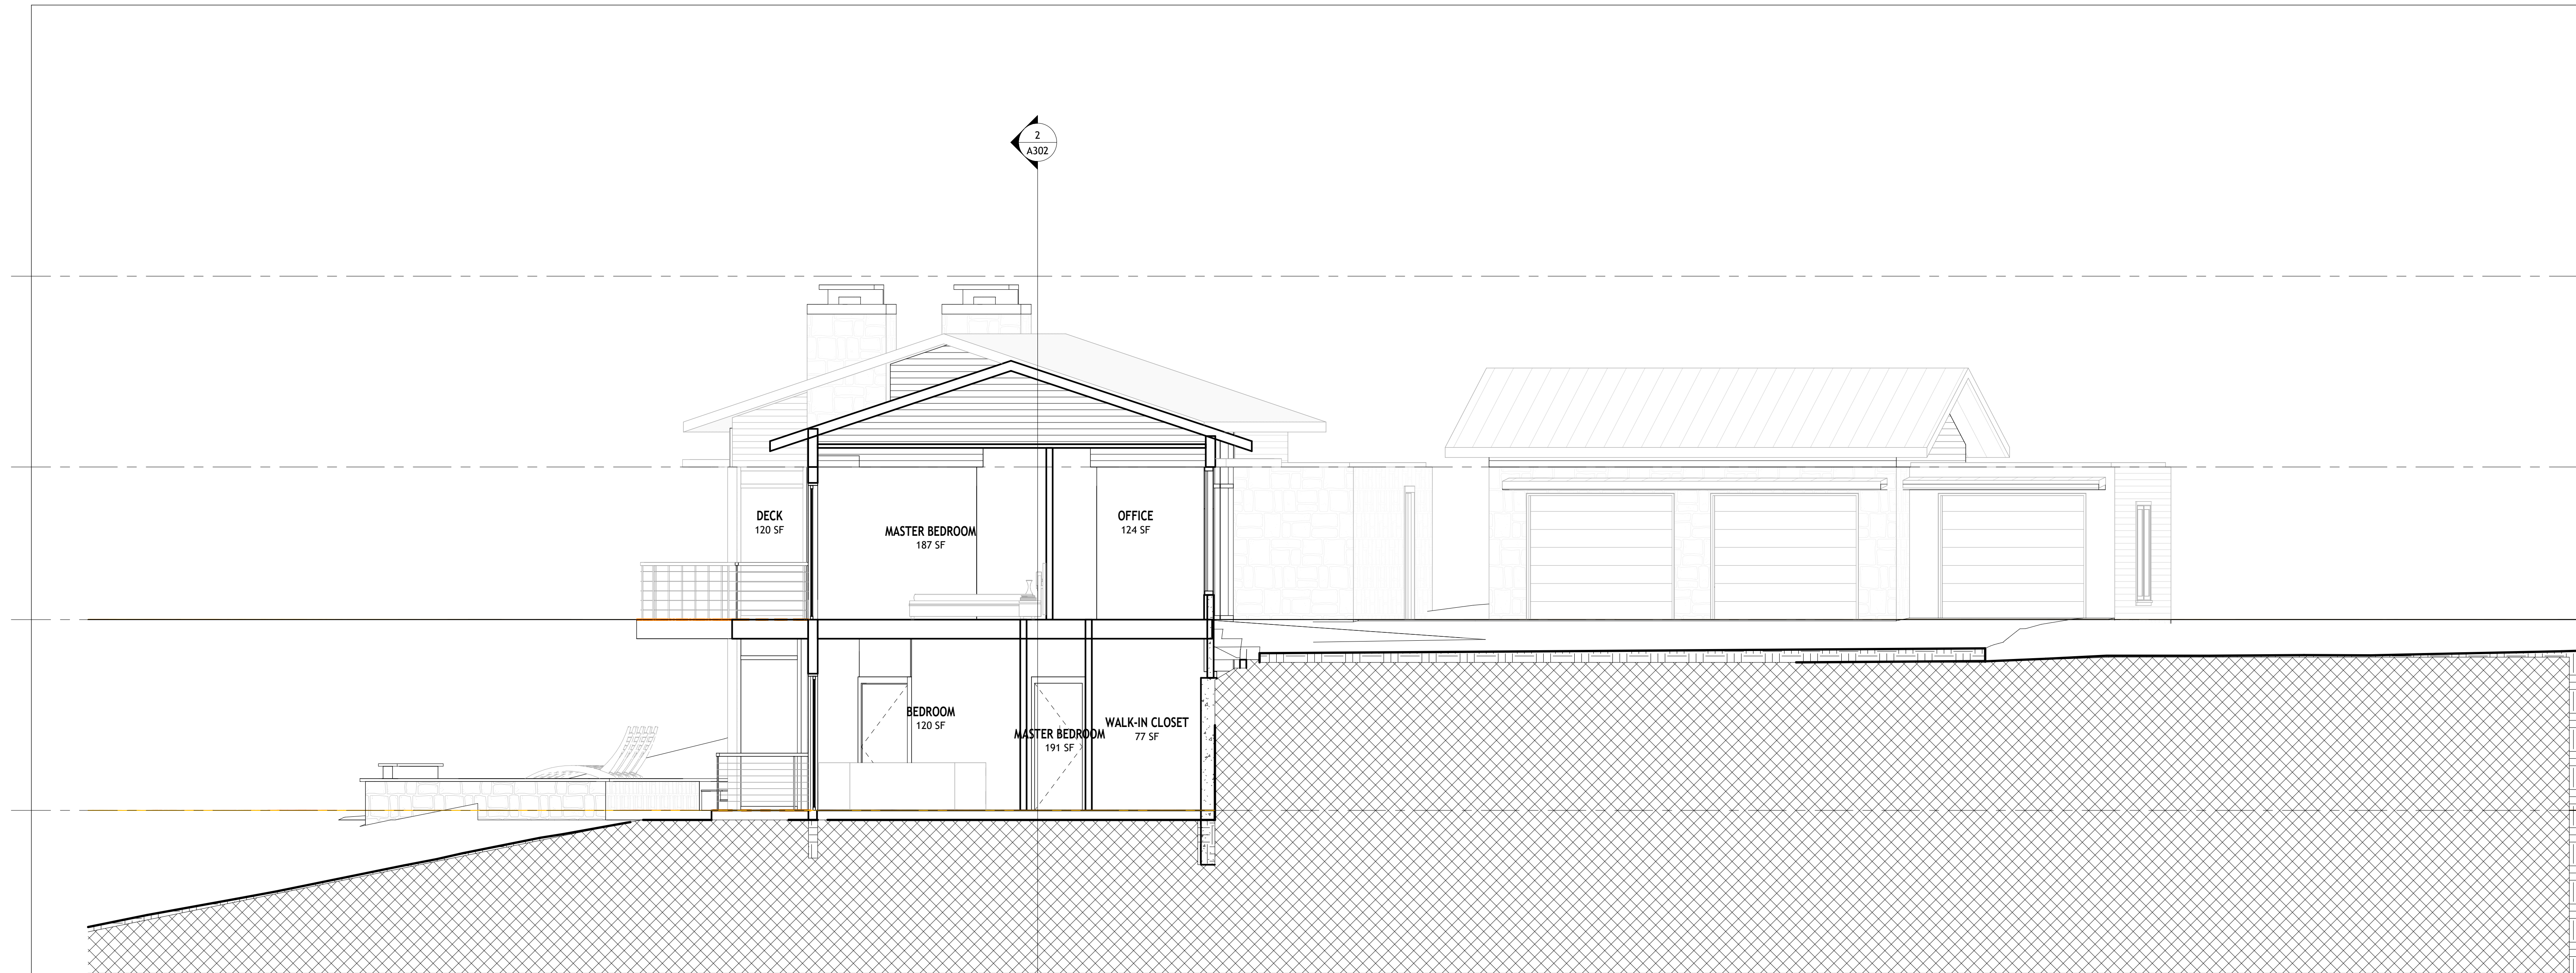

1 Section 5
1/4" = 1'-0"

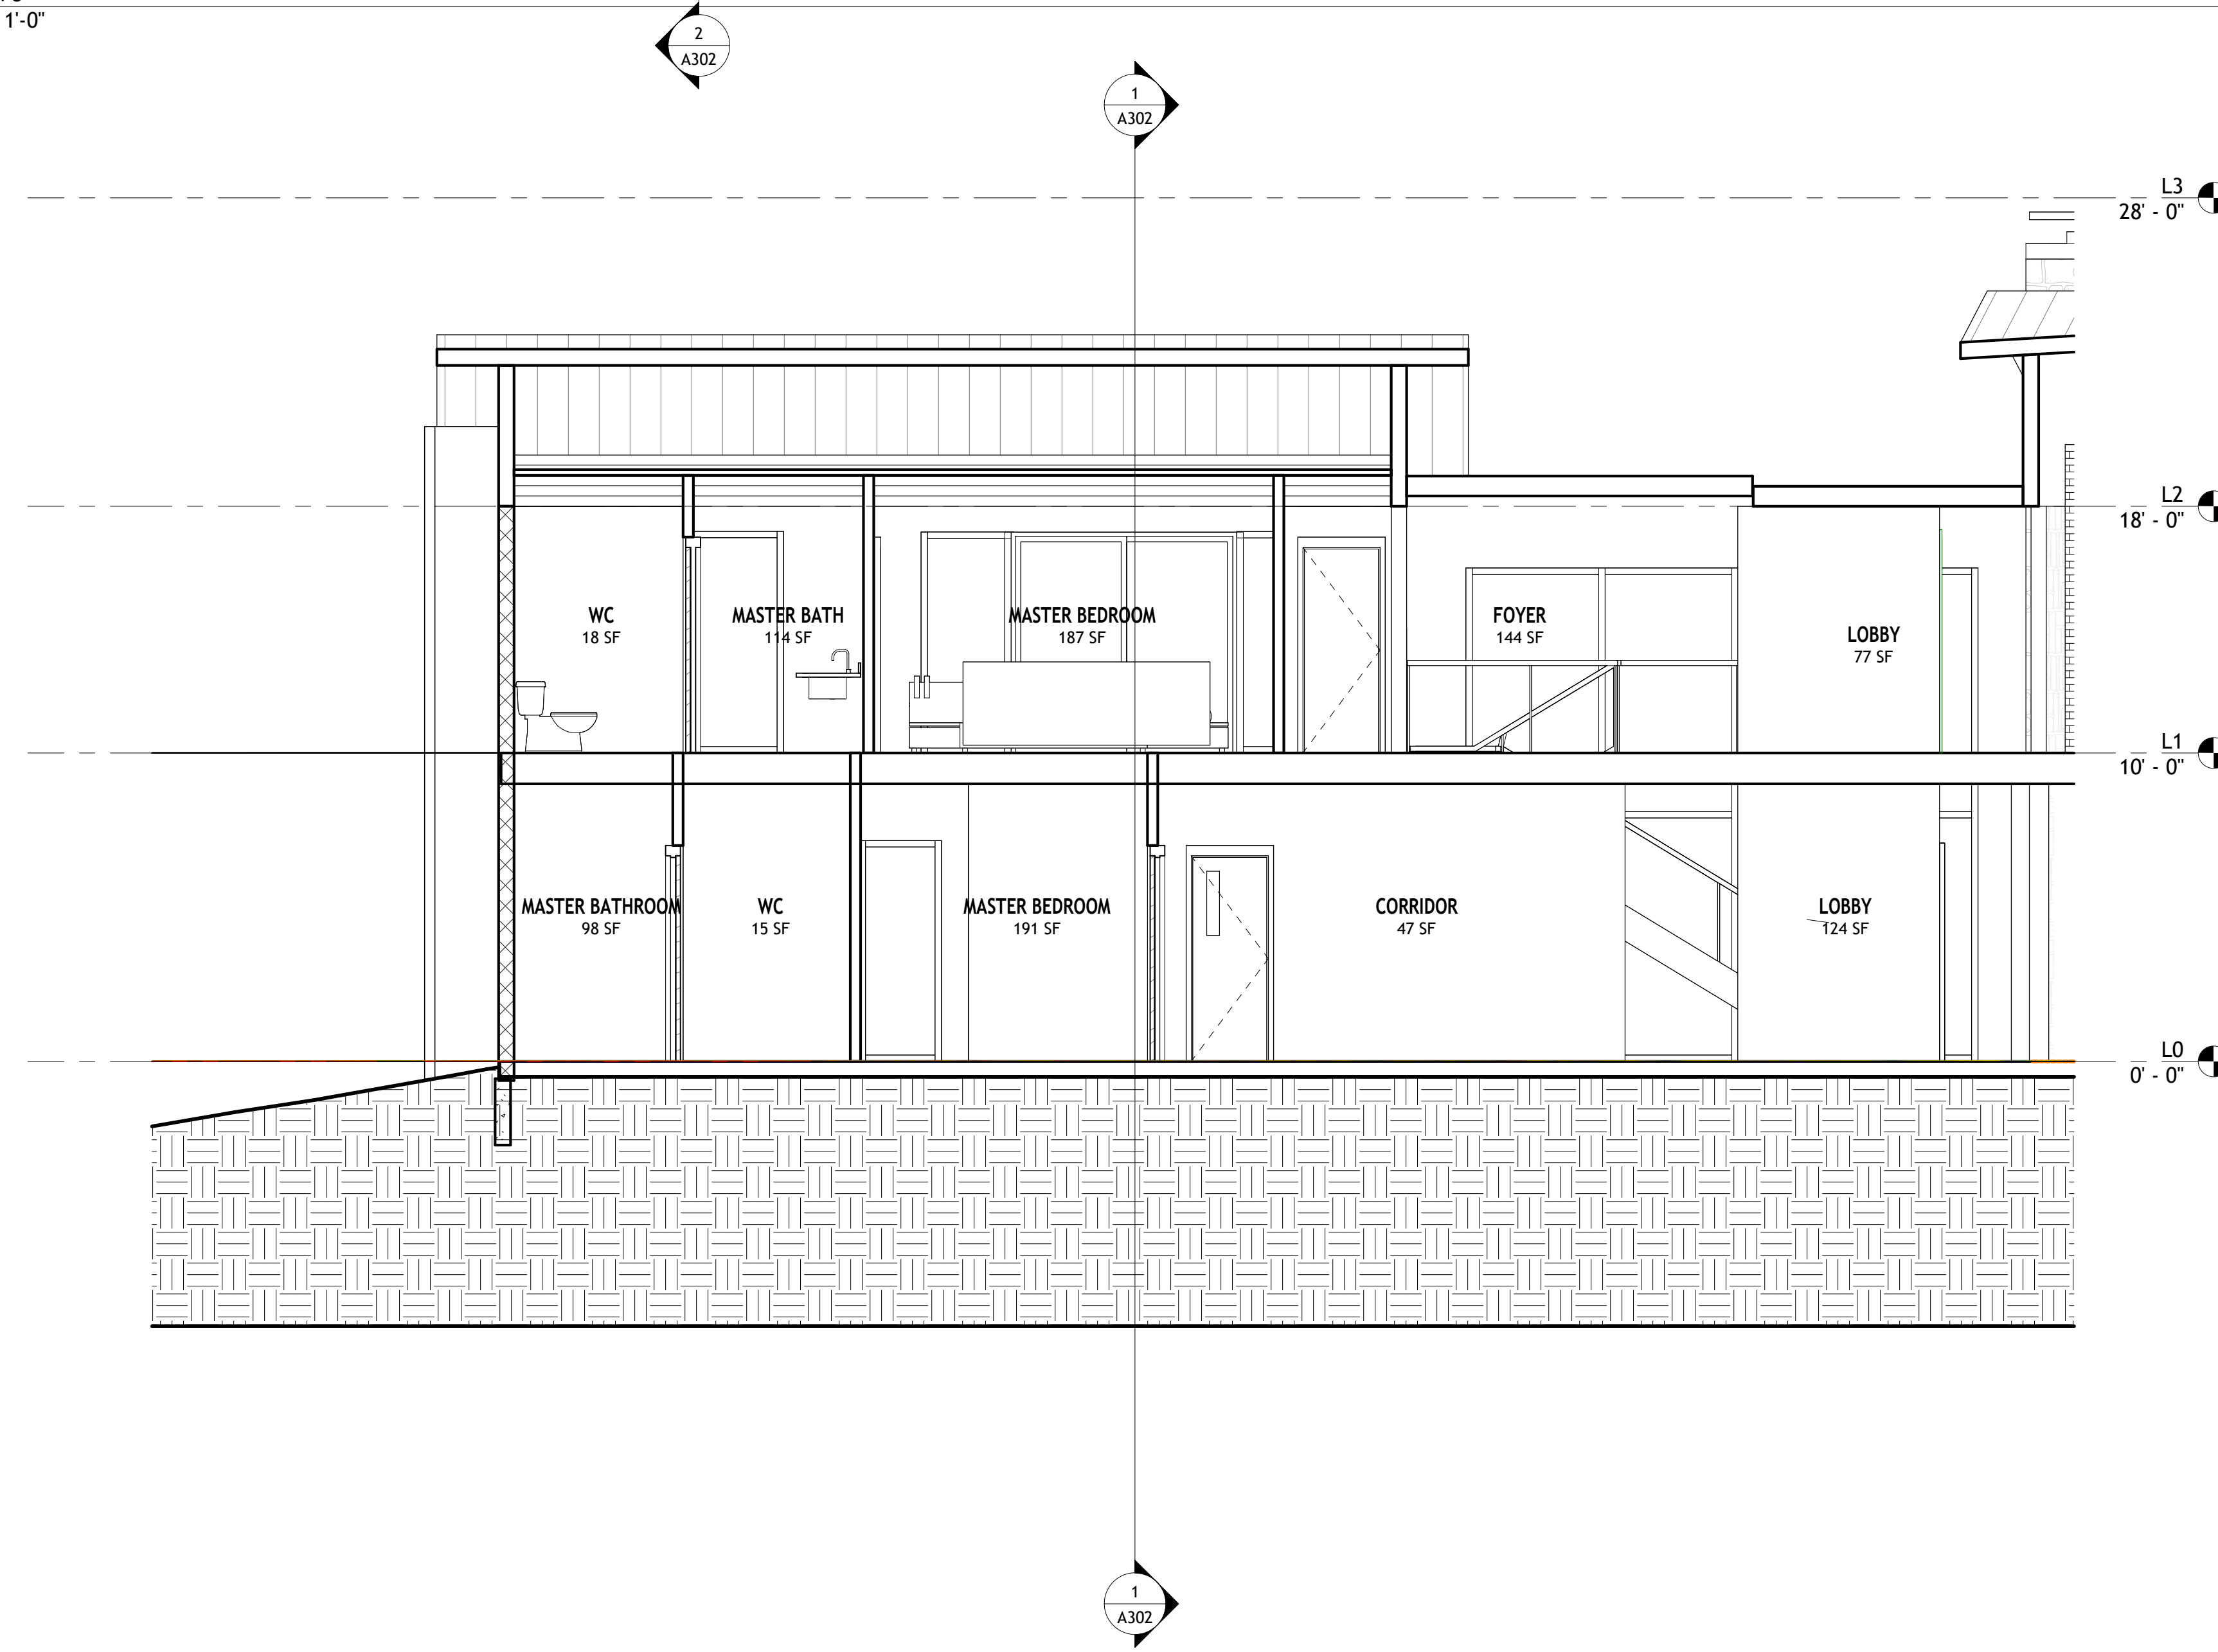

② Section 6
1/4" = 1'-0"



ELECTRICAL NOTE:

DEDICATED 20 AMP CIRCUIT FOR:
KITCHEN COUNTER, DISHWASHER, REFRIGERATOR,
MICRO OVEN, HOOD, GARBAGE DISPOSAL.
ALL RECEPTACLES SHALL BE TAMPER RESISTANT,
RECEPTACLES MAY NOT BE LOCATED MORE THAN 12 INCHES
BELOW THE COUNTER SURFACE AND OR BELOW A COUNTER
THAT EXTENDS MORE THAN 6 INCHES BEYOND THE COUNTER
EDGE.
NEW "EVSE" READY SPACE.
THE EVSE READY SPACE SHALL HAVE THE FOLLOWING: PANEL
CAPABILITY, 40A 2 POLE BREAKER, "TRACEWAY", NO. 8
CONDUCTORS INSTALLED TO THE ANTICIPATED CHARGER

LIGHTING NOTES:

- GARAGE, LAUNDRY ROOM, AND UTILITY ROOM LIGHTING SHALL BE HIGH EFFICACY LUMINARIES AND CONTROLLED BY A VACANCY SENSOR (MANUAL-ON OCCUPANCY SENSOR AND MOTION SENSOR , AND SHALL NOT HAVE A CONTROL THAT ALLOWS THE LUMINARIES TO BE TURNED ON AUTOMATICALLY OR THAT HAS AN OVERRIDE ALLOWING THE LUMINARIES TO BE ALWAYS ON).

- ALL RECESS LIGHTS SHALL BE IC RATED, ELECTRONIC BALLAST AND A.D.A.T.

 
Consultant
Address
Address
Address
Phone

Consultant
Address
Address
Address
Phone

[illegible]

Consultant
Address
Address
Address
Phone

Consultant
Address
Address
Address
Phone

SYMBOL	DESCRIPTION
	DUPLEX RECEPTACLE 12" A.F.F.
	RECESSED LIGHT FIXTURE
	WALL SCONCE
	CEILING MOUNTED LIGHT FIXTURE
	FIXTURE - EXHAUST FAN 100 CFU
	SINGLE POLE TOGGLE SWITCH
	THREE WAY TOGGLE SWITCH
	FAN
	GROUND FAULT CIRCUIT INTERRUPTER
	CARBON MONOXIDE DETECTOR
	SMOKE DETECTOR
	ELECTRICAL PANEL 200 AMP


[illegible]


4631 Dunn Ln
Angels Camp, Ca
95222.

NEW RESIDENTIAL CONSTRUCTION

Power Plans

Project Number	Project Number
Date	Issue Date
Drawn By	Author
Checked By	Checker
E101	
Scale	1/4" = 1'-0"

 

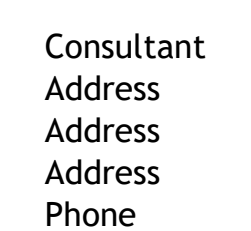

- GARAGE, LAUNDRY ROOM, AND UTILITY ROOM LIGHTING SHALL BE HIGH EFFICACY
- LUMINARIES AND CONTROLLED BY A VACANCY SENSOR (MANUAL ON OCCUPANCY SENSOR AND MOTION SENSOR , AND SHALL NOT HAVE A CONTROL THAT ALLOWS THE LUMINARIES TO BE TURNED ON AUTOMATICALLY OR THAT HAS AN OVERRIDE ALLOWING THE LUMINARIES TO BE ALWAYS ON).
- ALL RECESS LIGHTS SHALL BE IC RATED, ELECTRONIC BALLAST AND AT.

[illegible]

Scale	1/4" = 1'-0"
-------	--------------










Consultant
Address
Address
Address
Phone

[illegible]

NEW RESIDENTIAL CONSTRUCTION

Project Number	Project Number
Date	Issue Date
Drawn By	Author
Checked By	Checker

Scale $1/4" = 1'-0"$

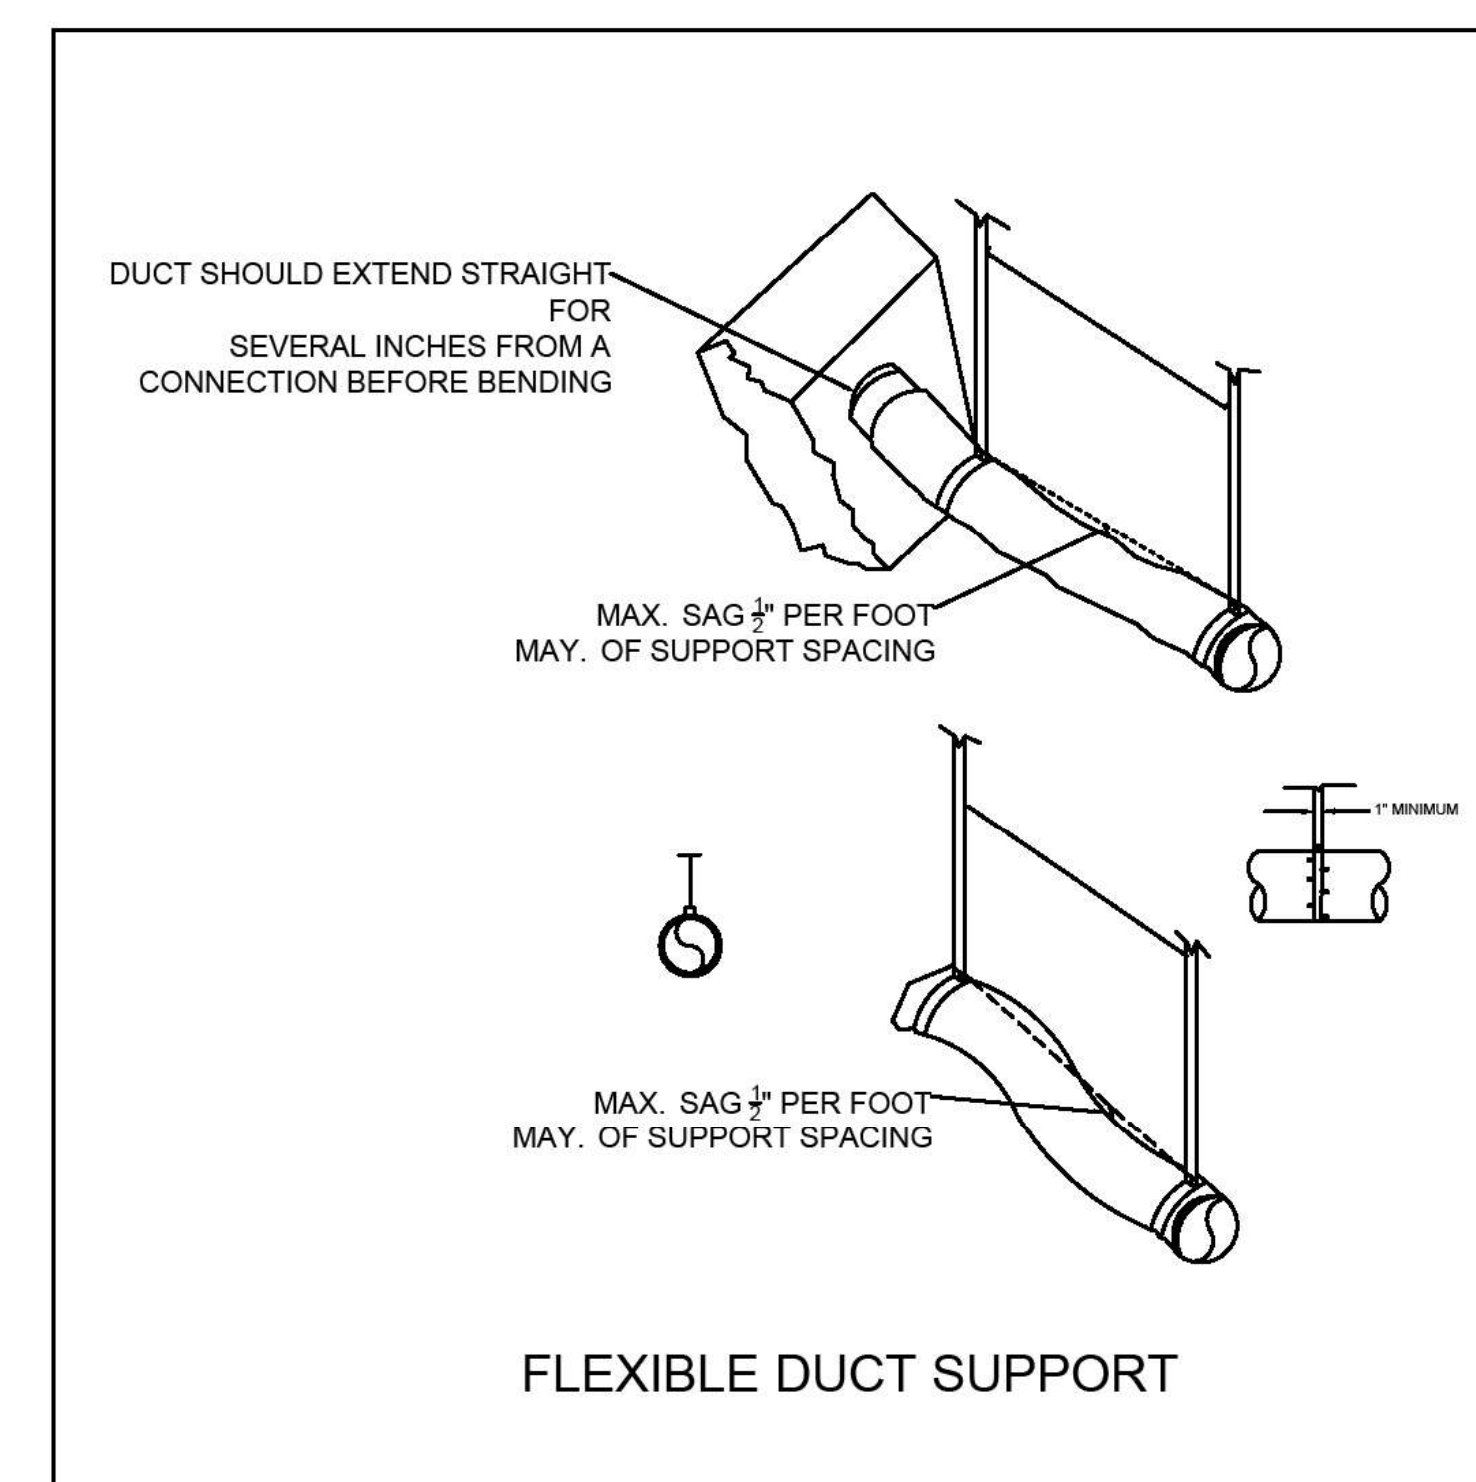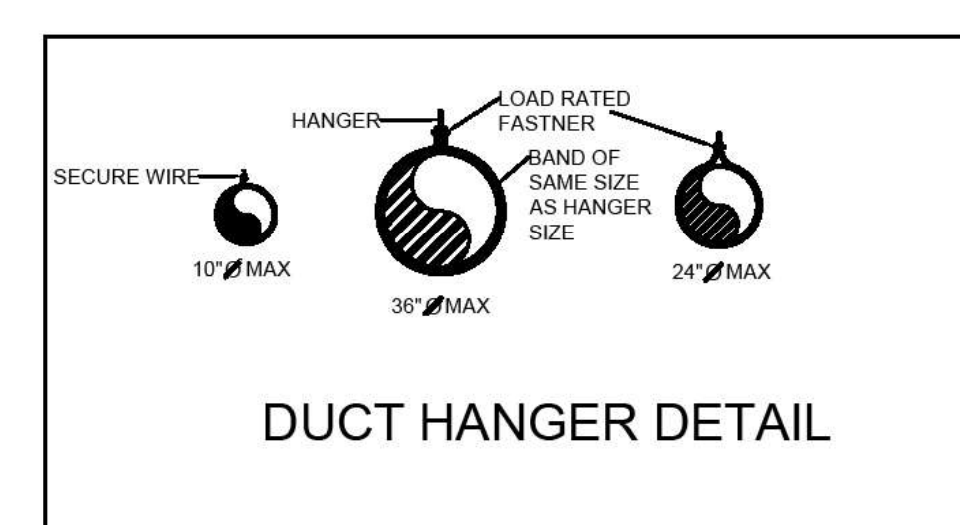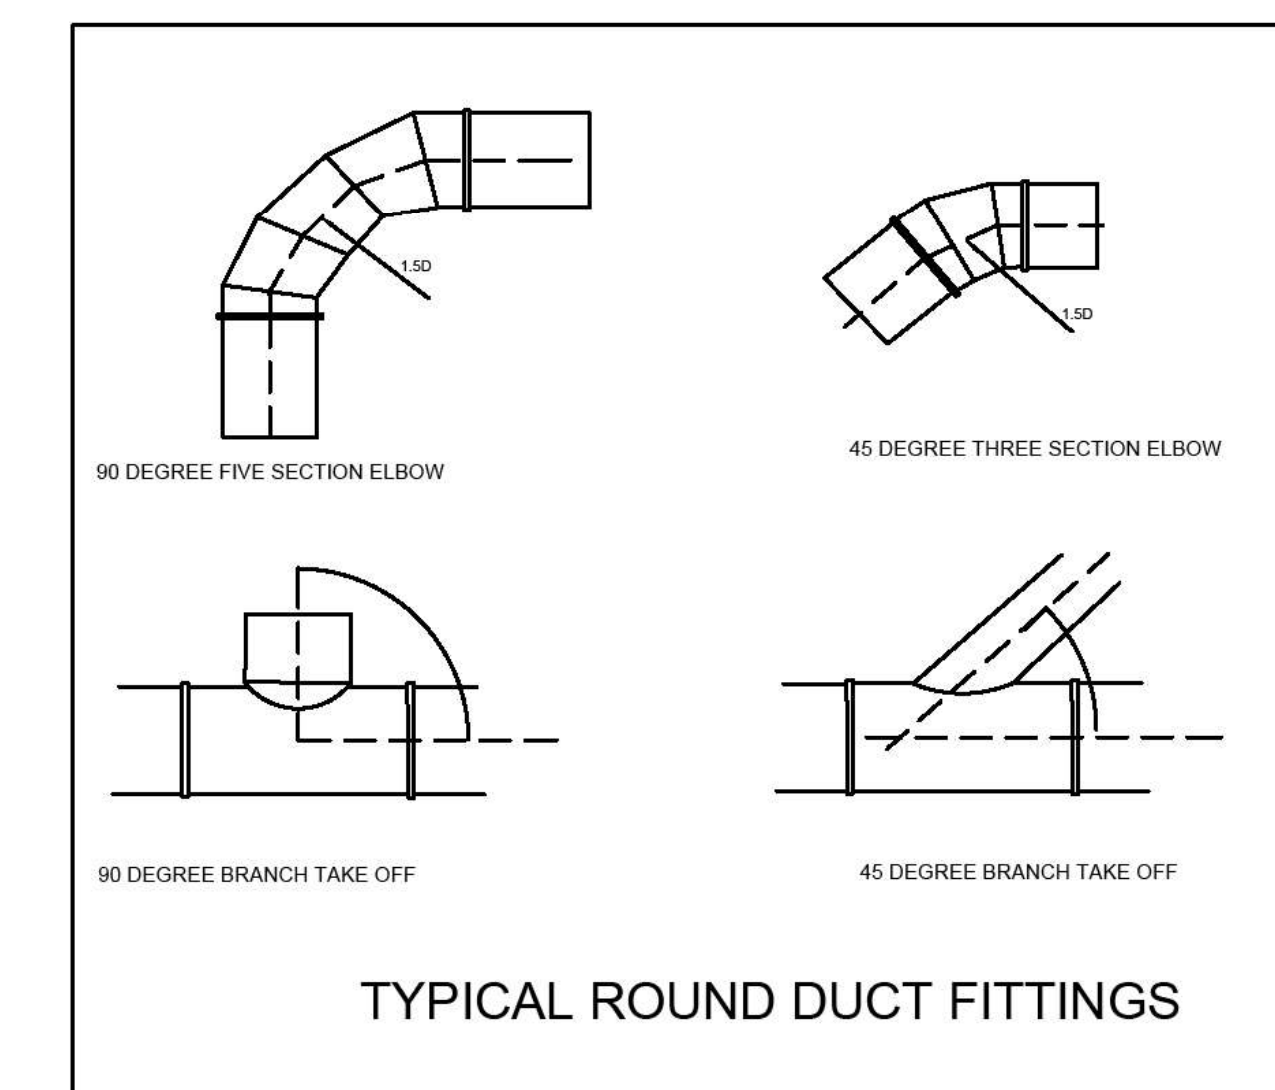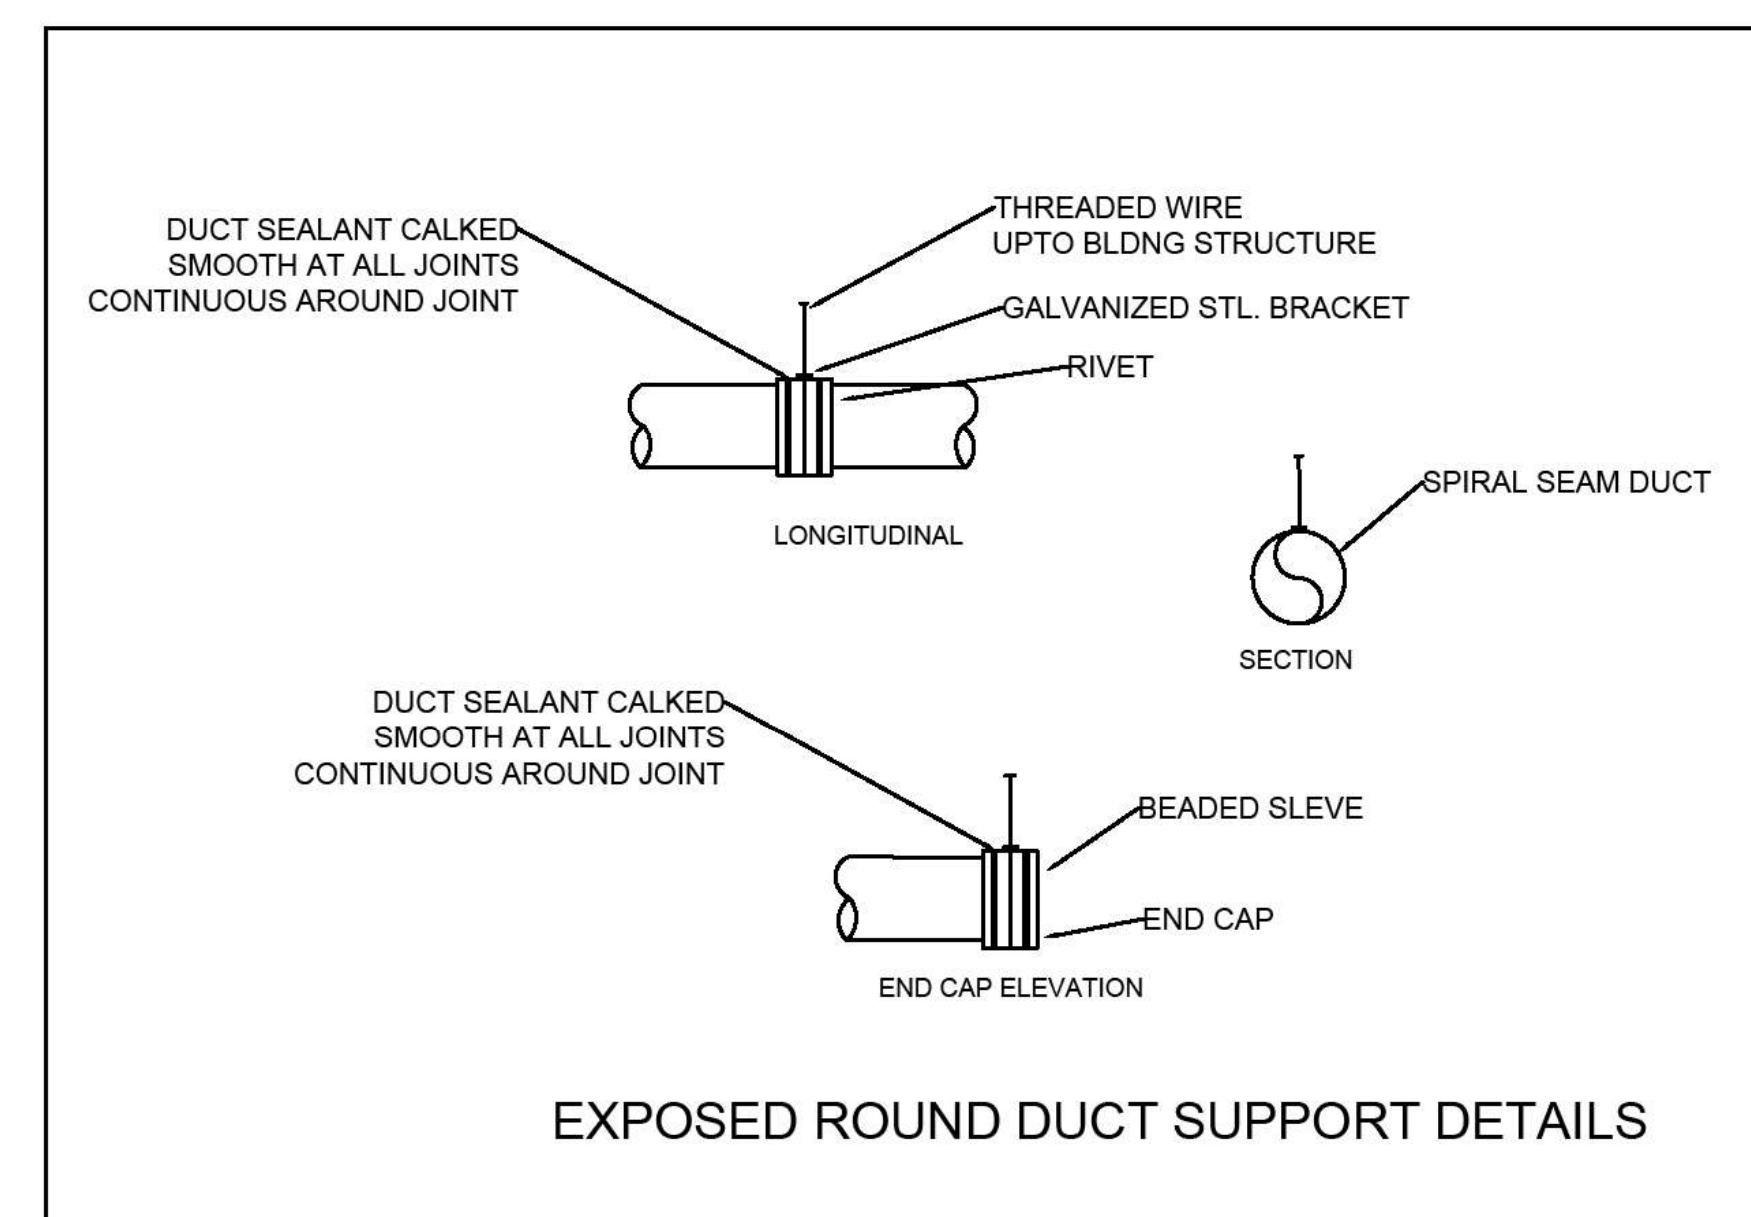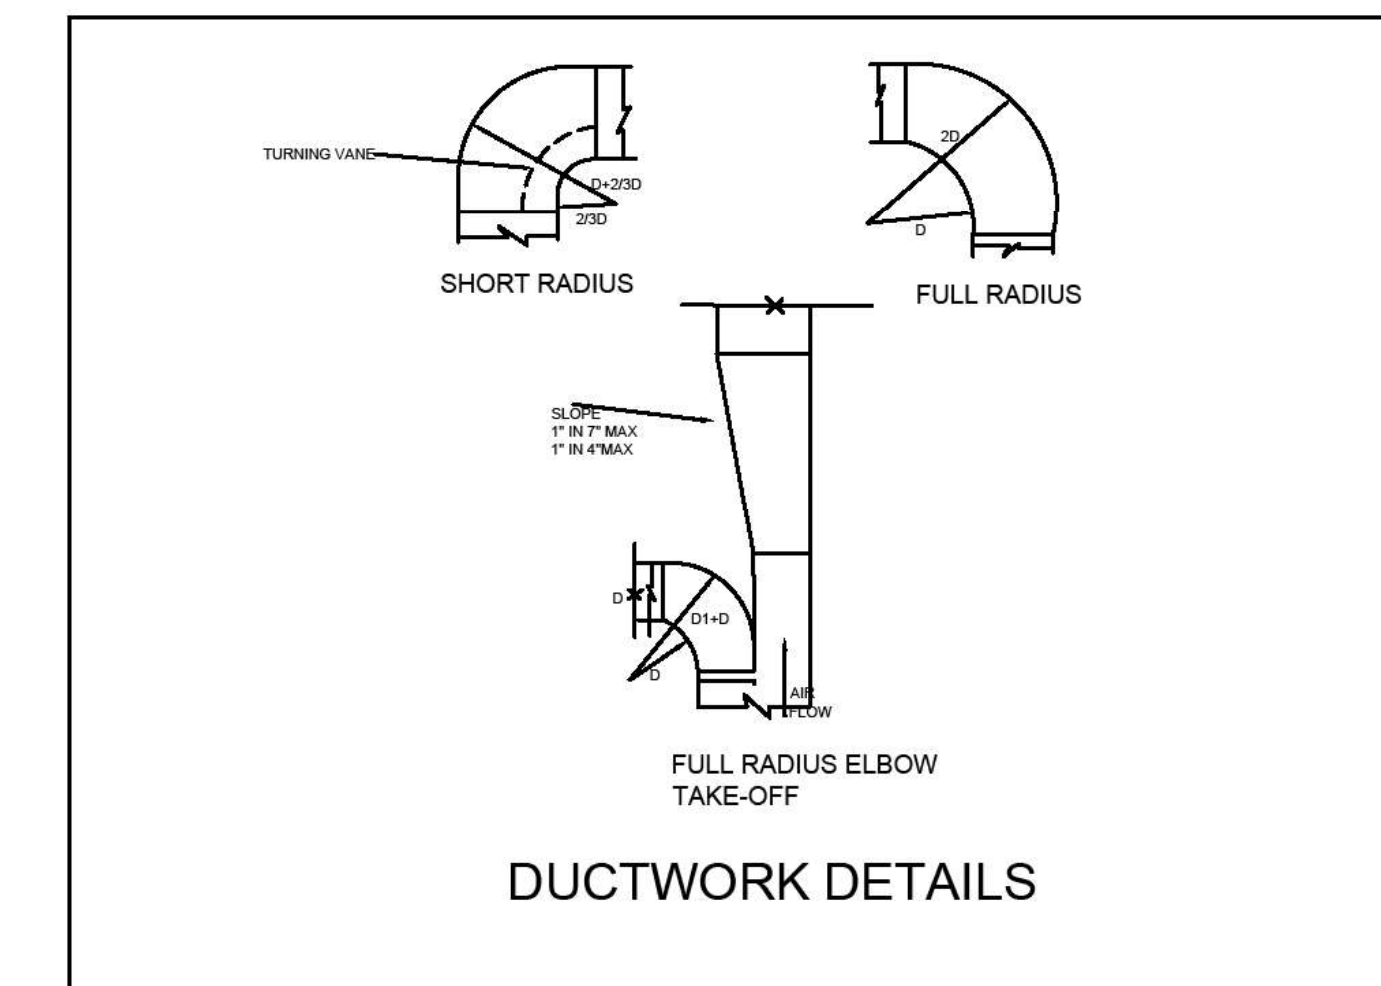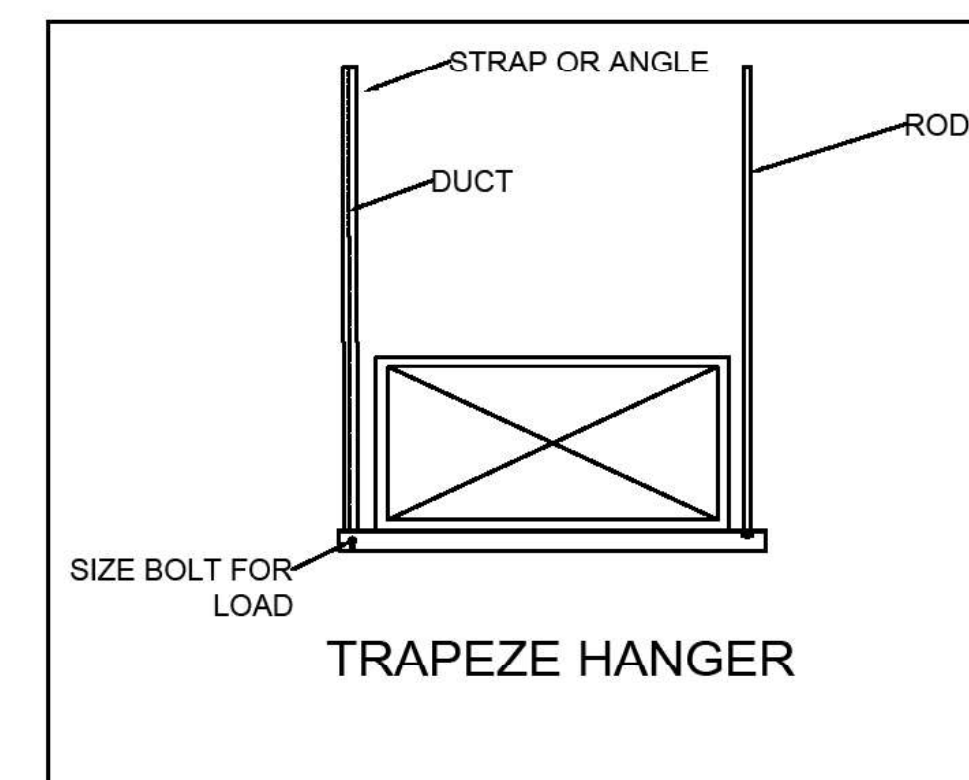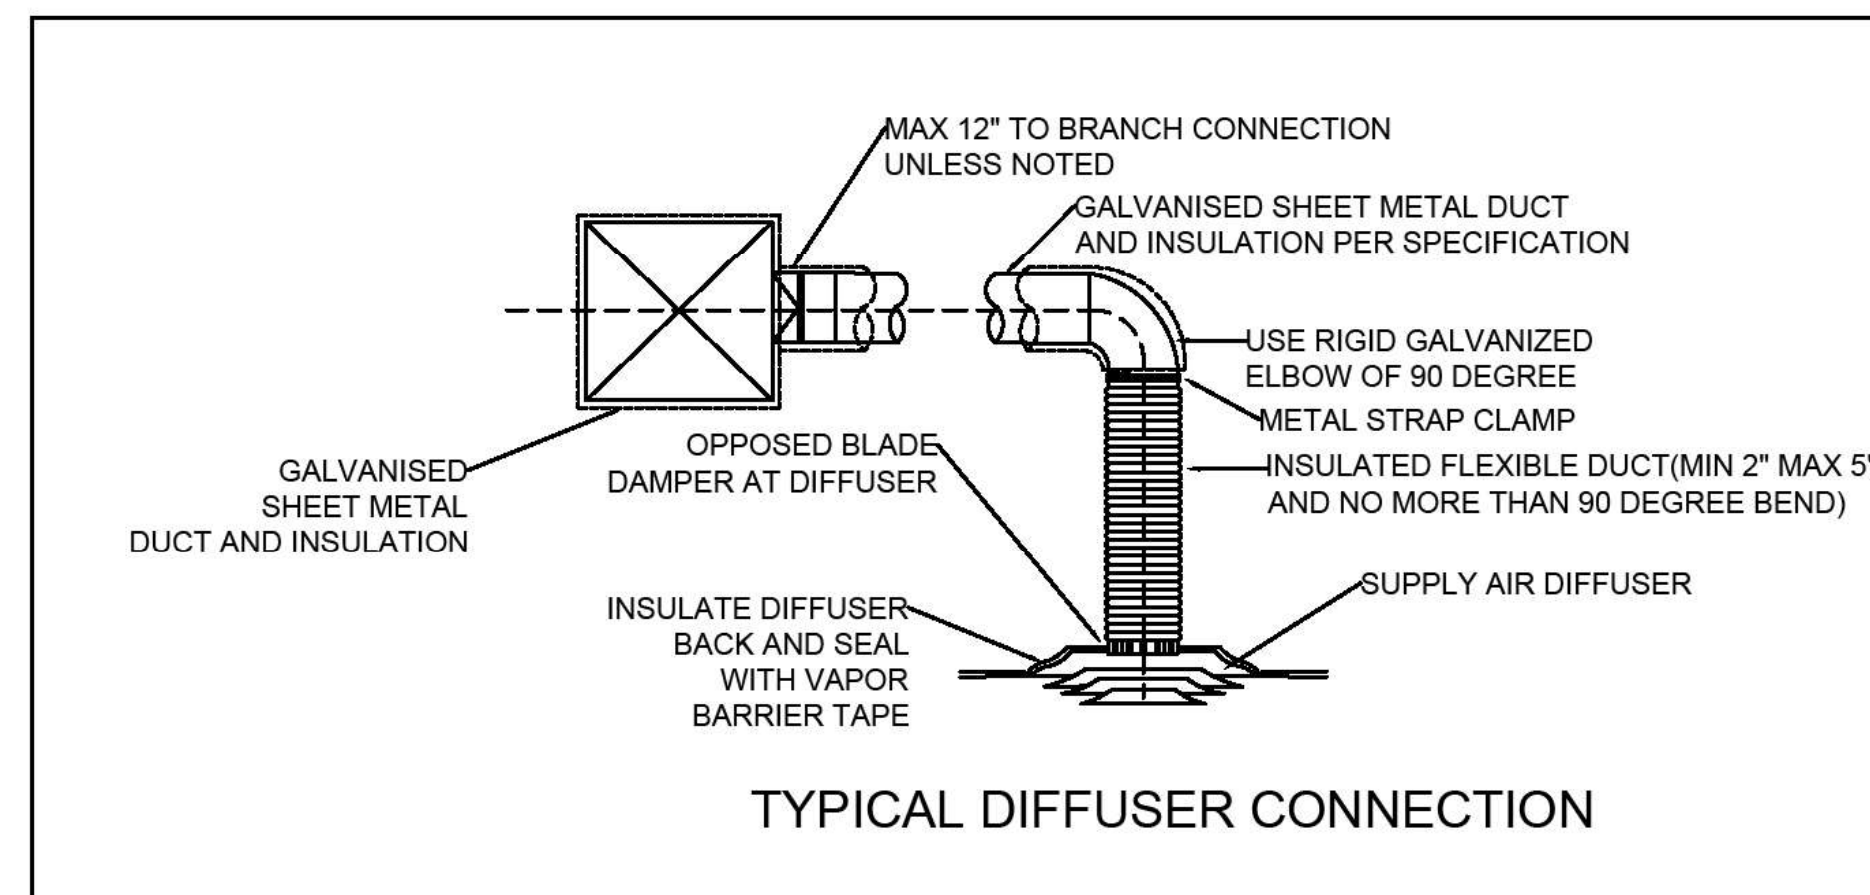

Consultant
Address
Address
Address
Phone

Consultant
Address
Address
Address
Phone

Consultant
Address
Address
Address
Phone

Consultant
Address
Address
Address
Phone

Consultant
Address
Address
Address
Phone

[illegible]

4631 Dunn Ln
Angels Camp, Ca
95222.



NEW RESIDENTIAL CONSTRUCTION

Mechanical DETAILS

Project Number	Project Number
Date	Issue Date
Drawn By	Author
Checked By	Checker

M100B



Scale	1/4" = 1'-0"
-------	--------------

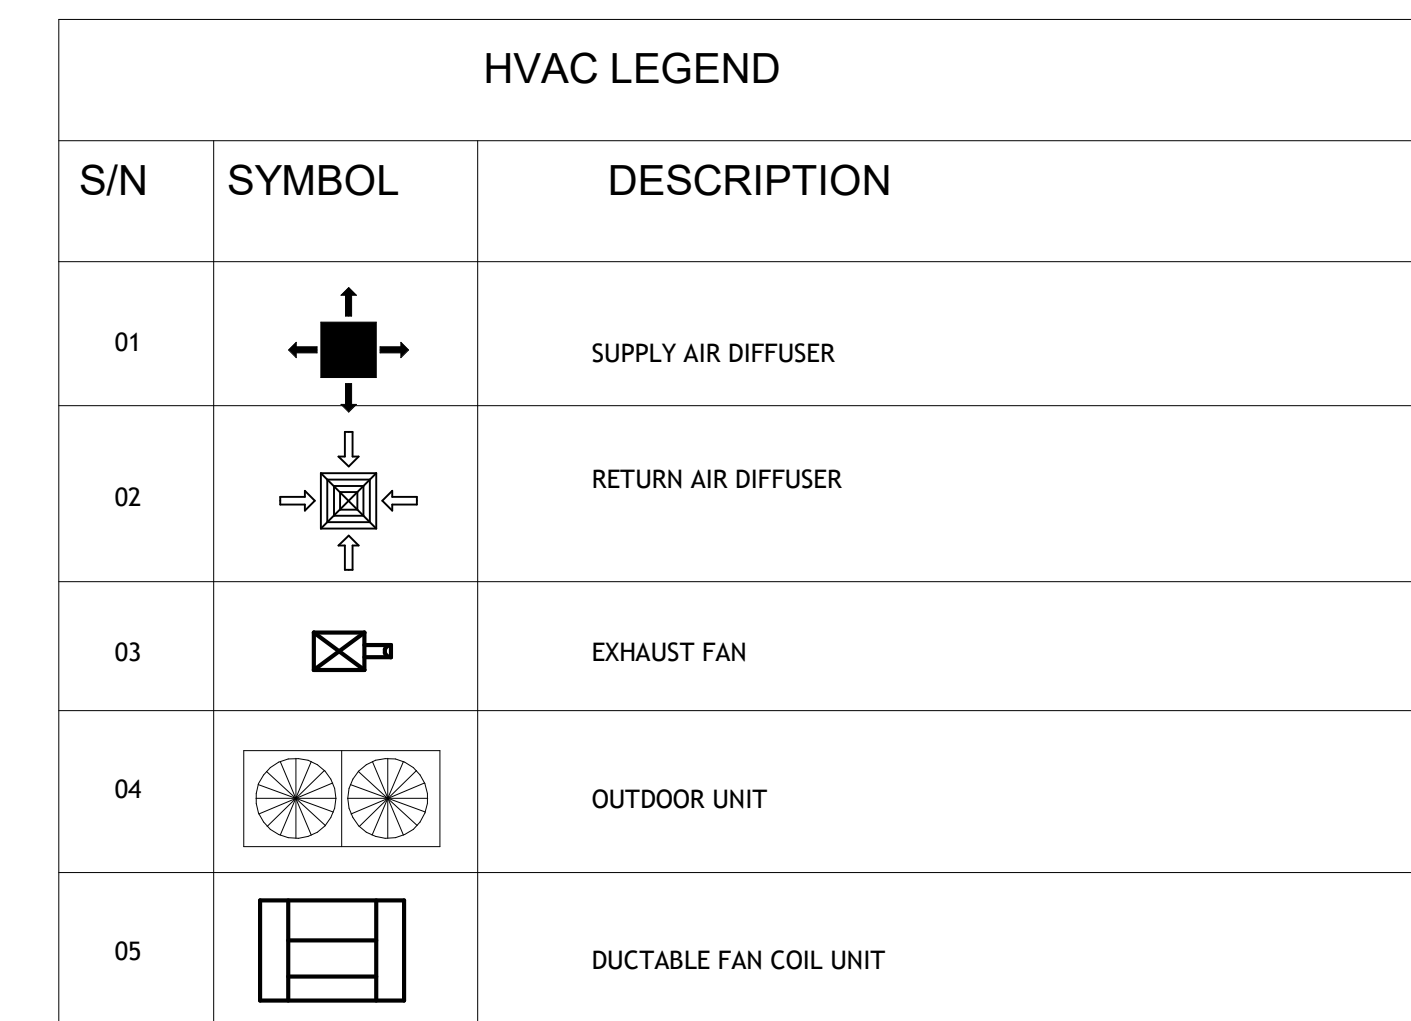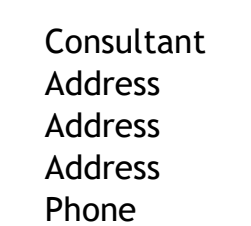







Mechanical Plans

Project Number	Project Number
Date	Issue Date
Drawn By	Author
Checked By	Checker
	
Scale	1/4" = 1'-0"

6/2/2025 2:48:06 PM

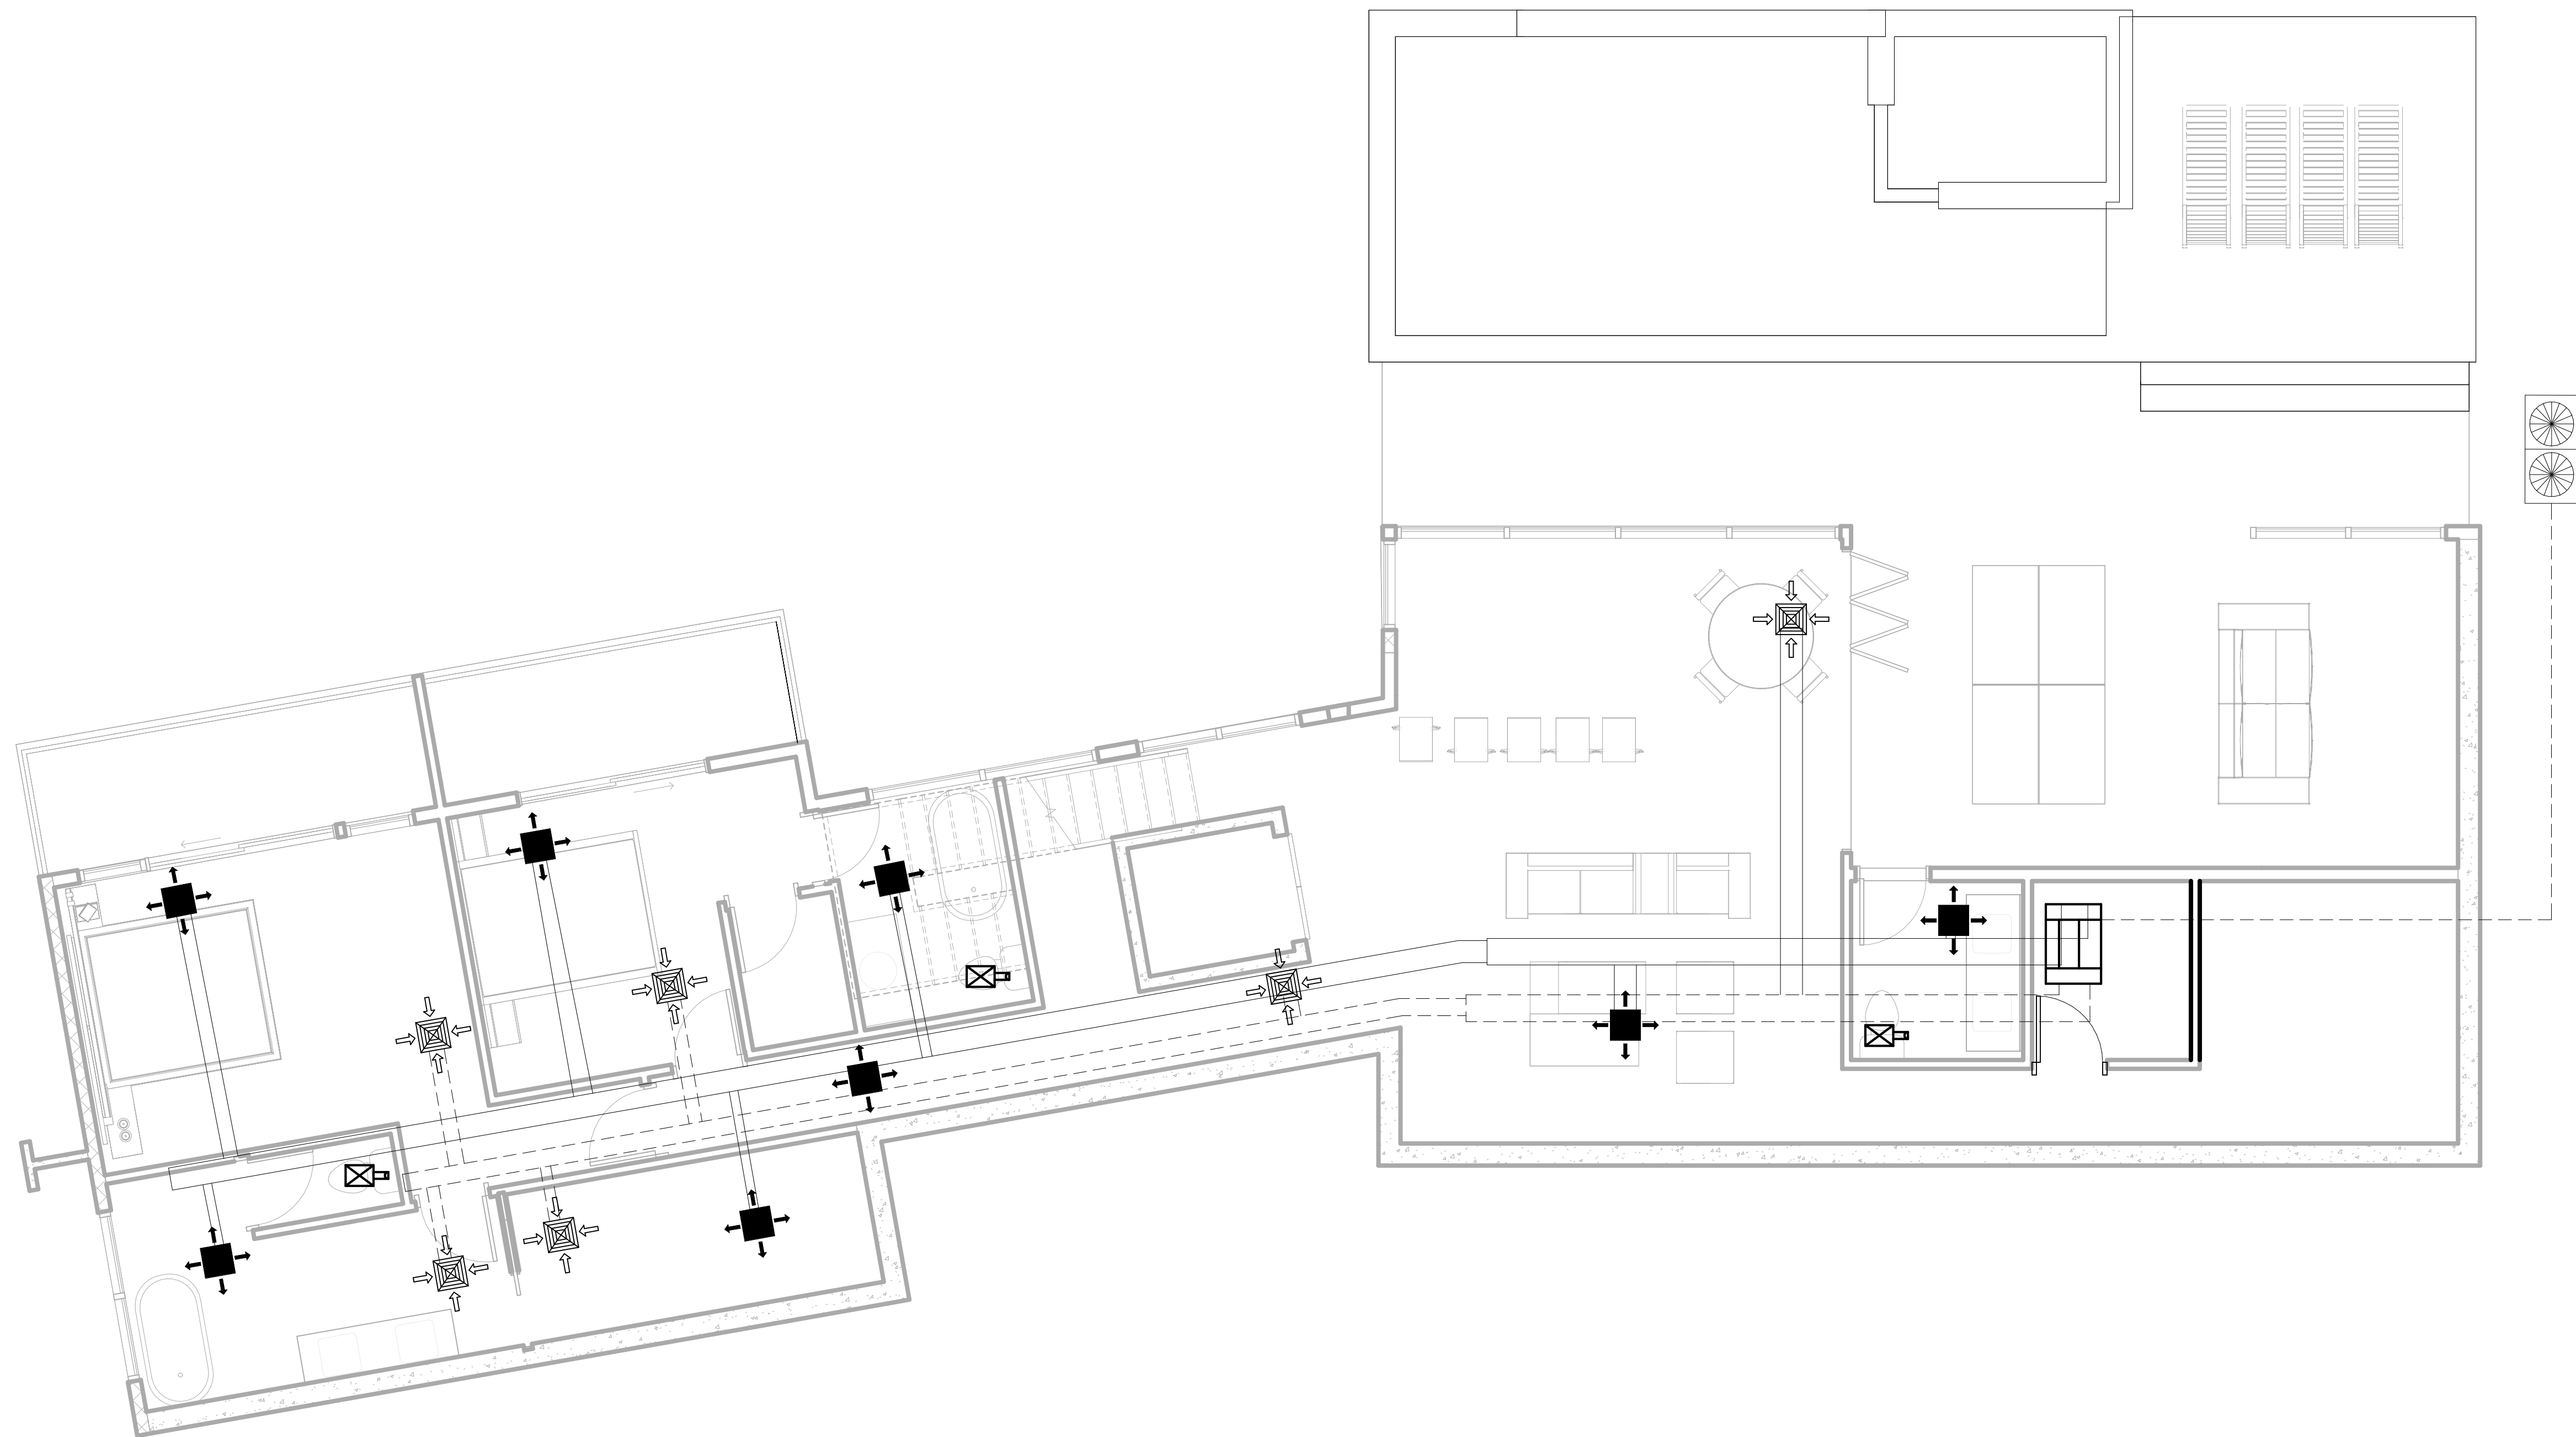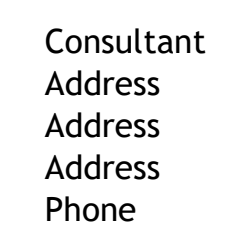

Scale	1/4" = 1'-0"
-------	--------------

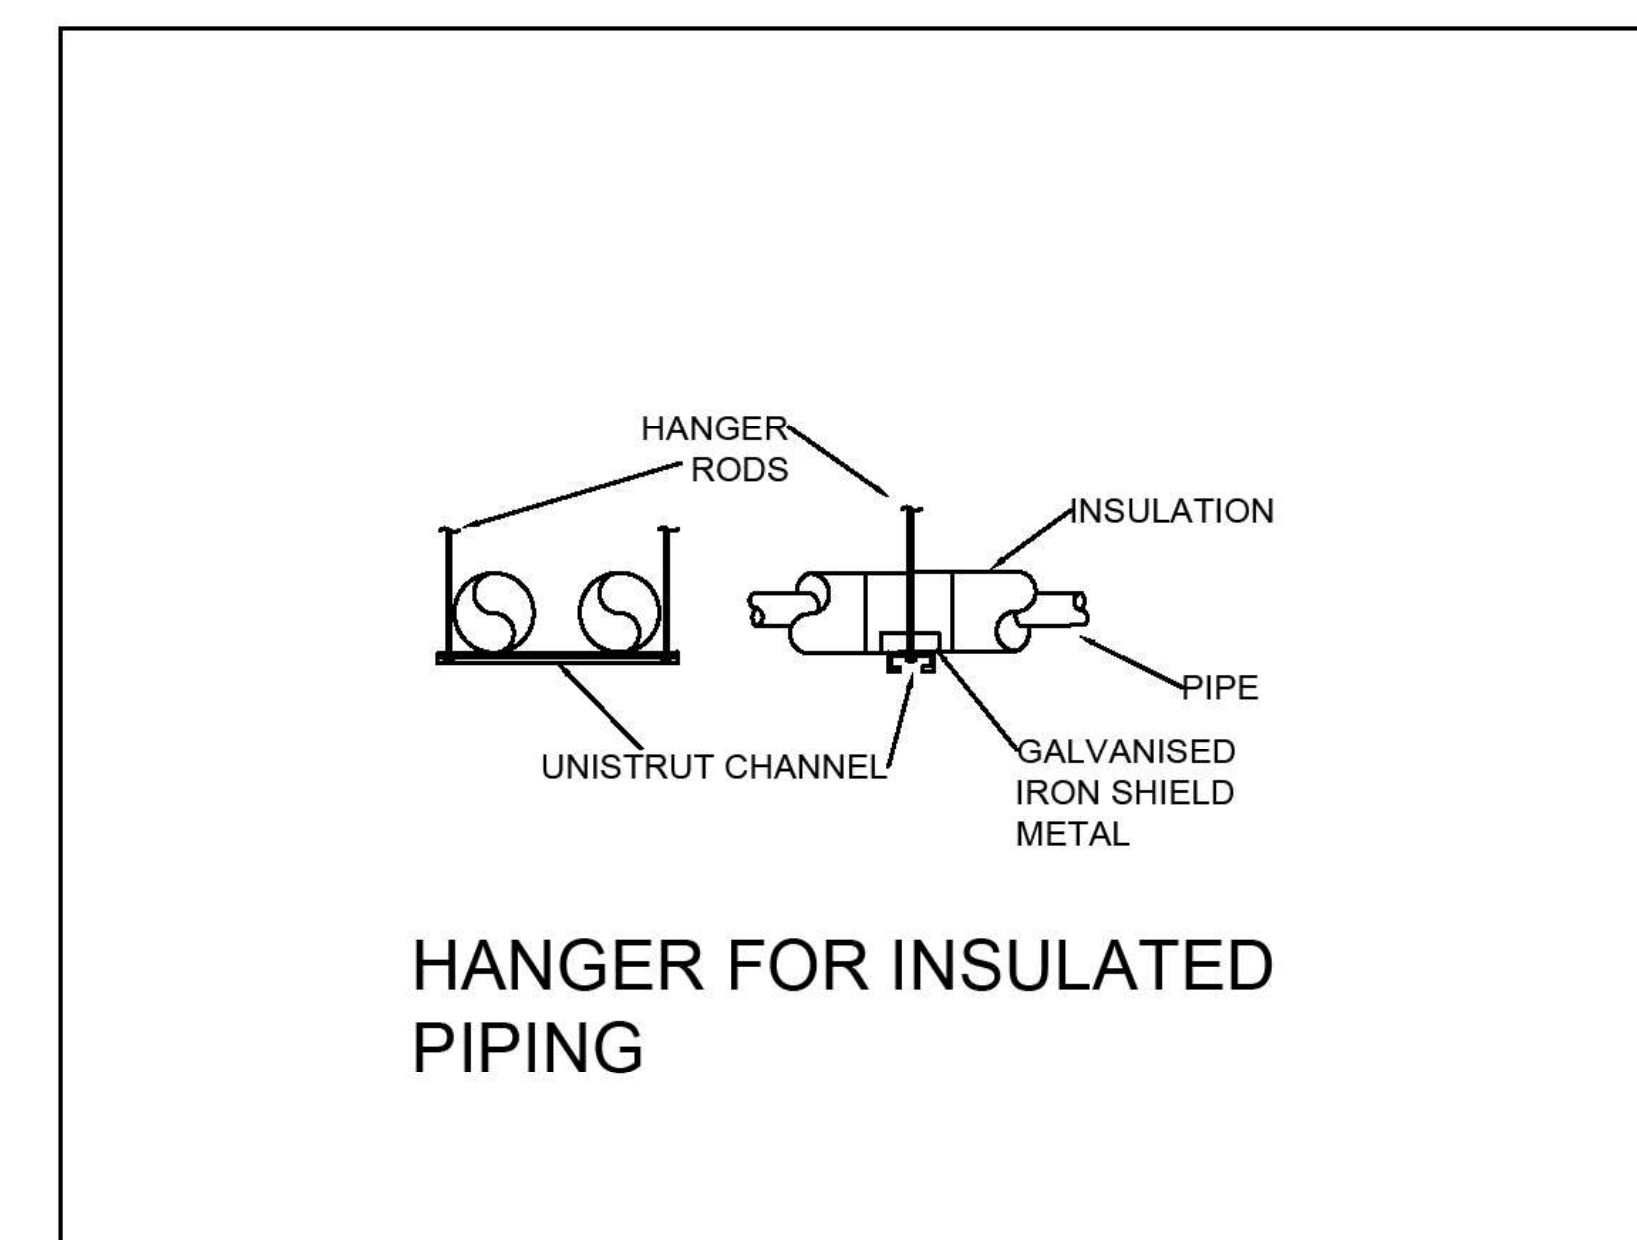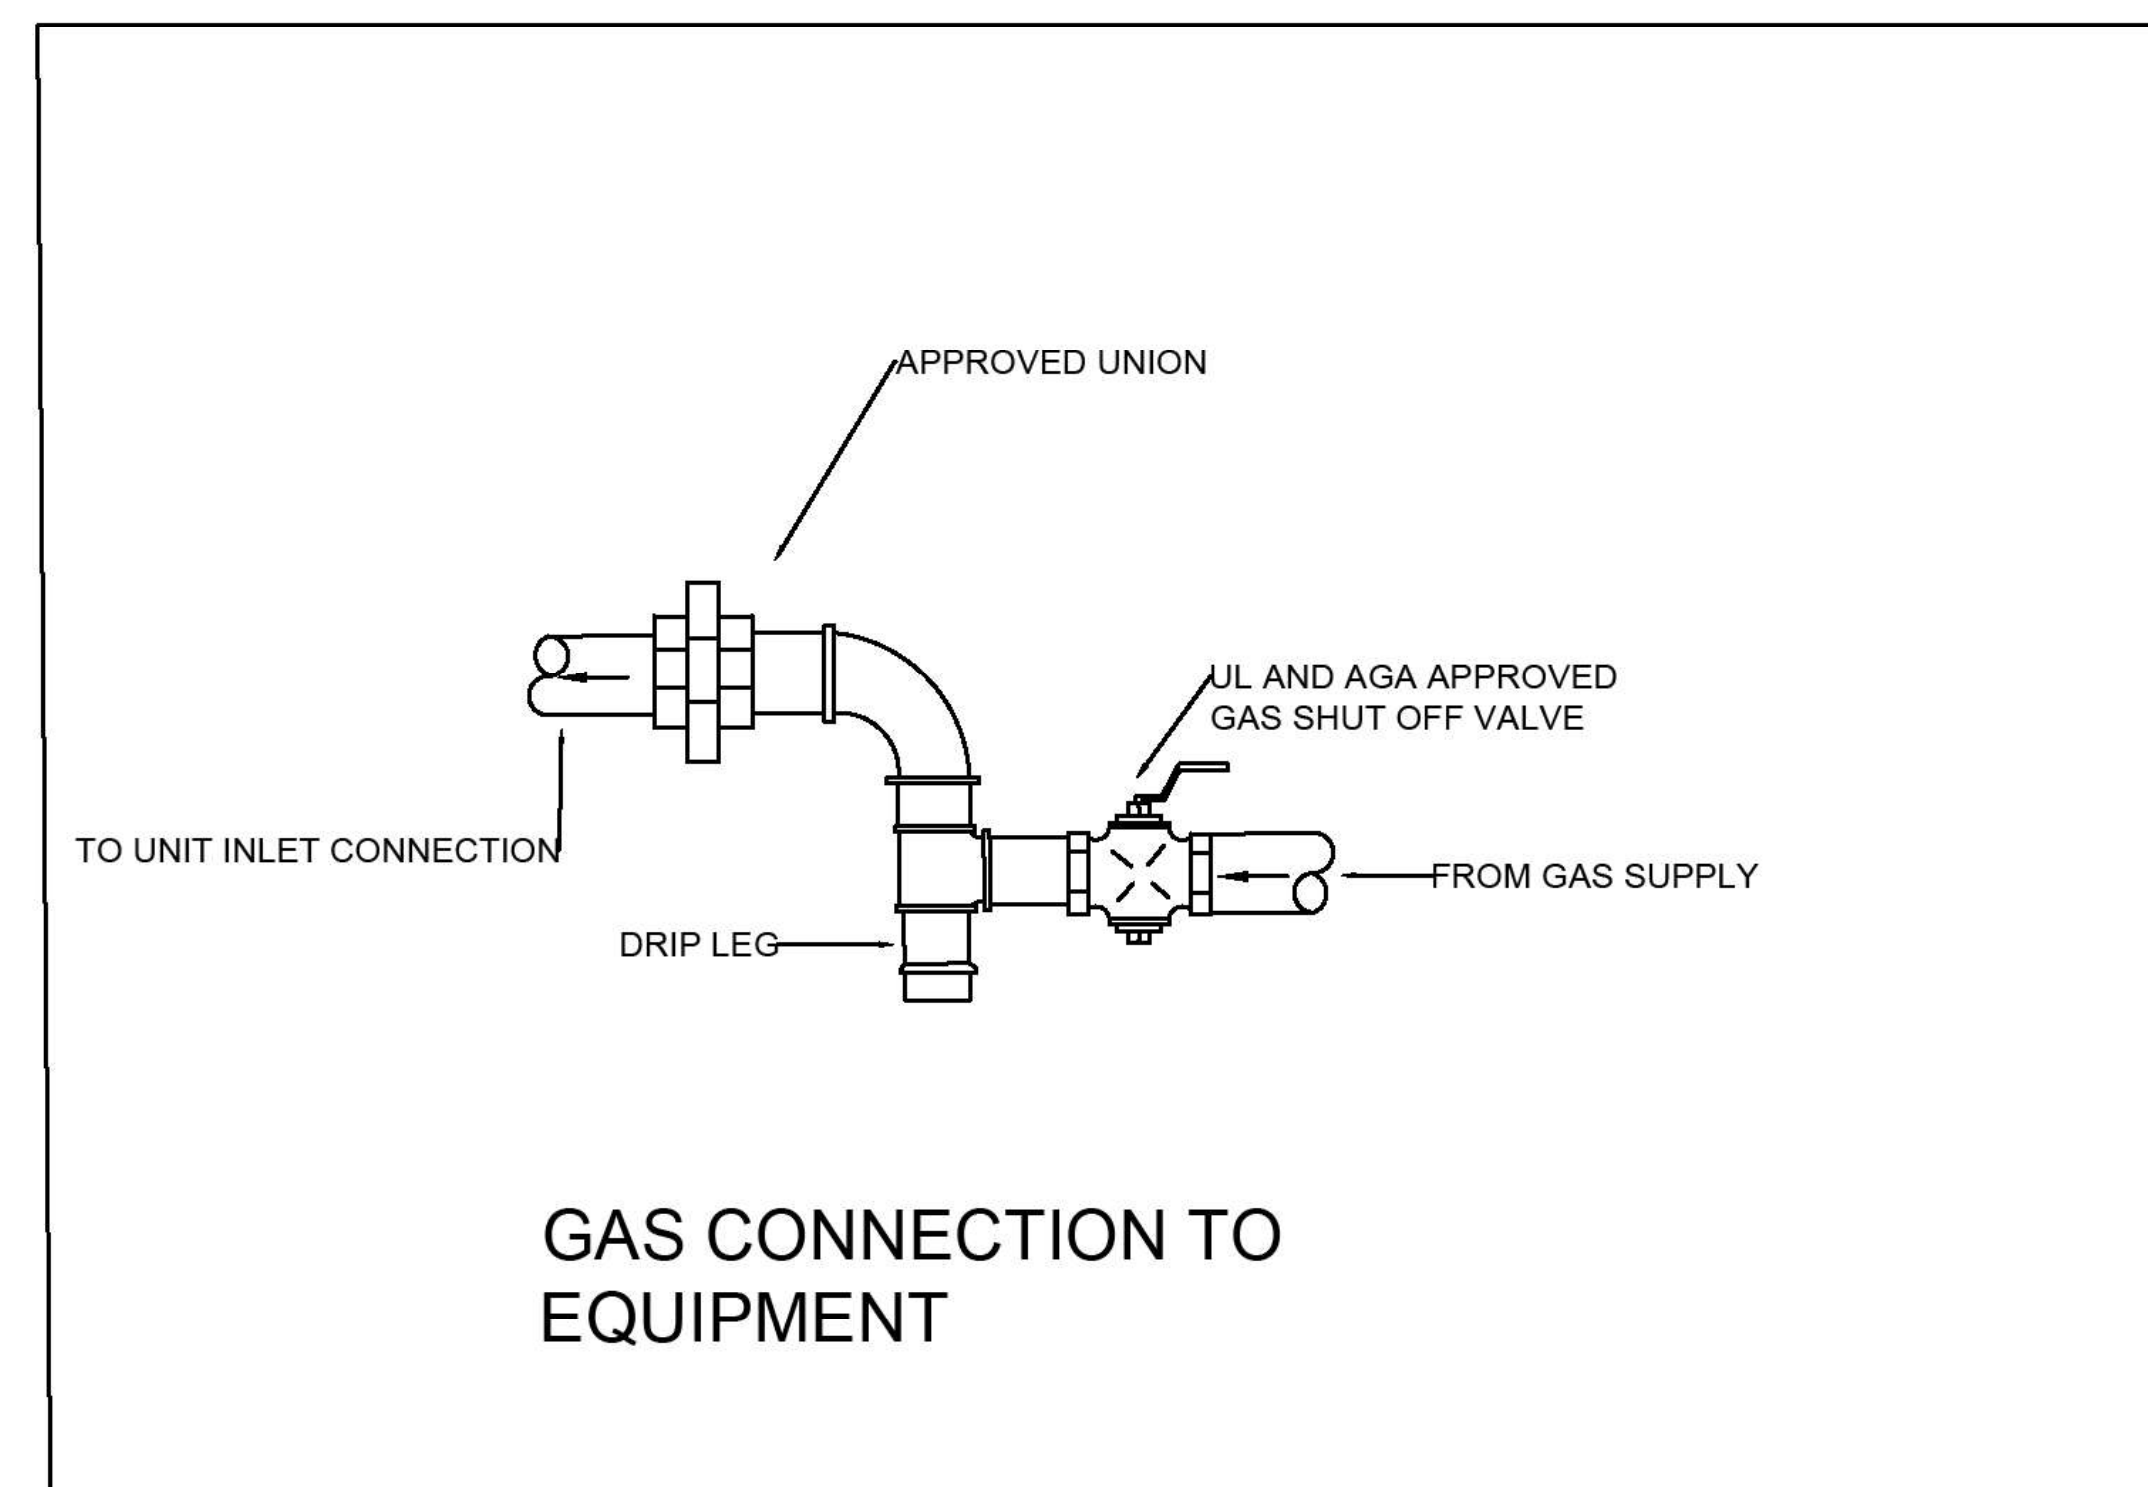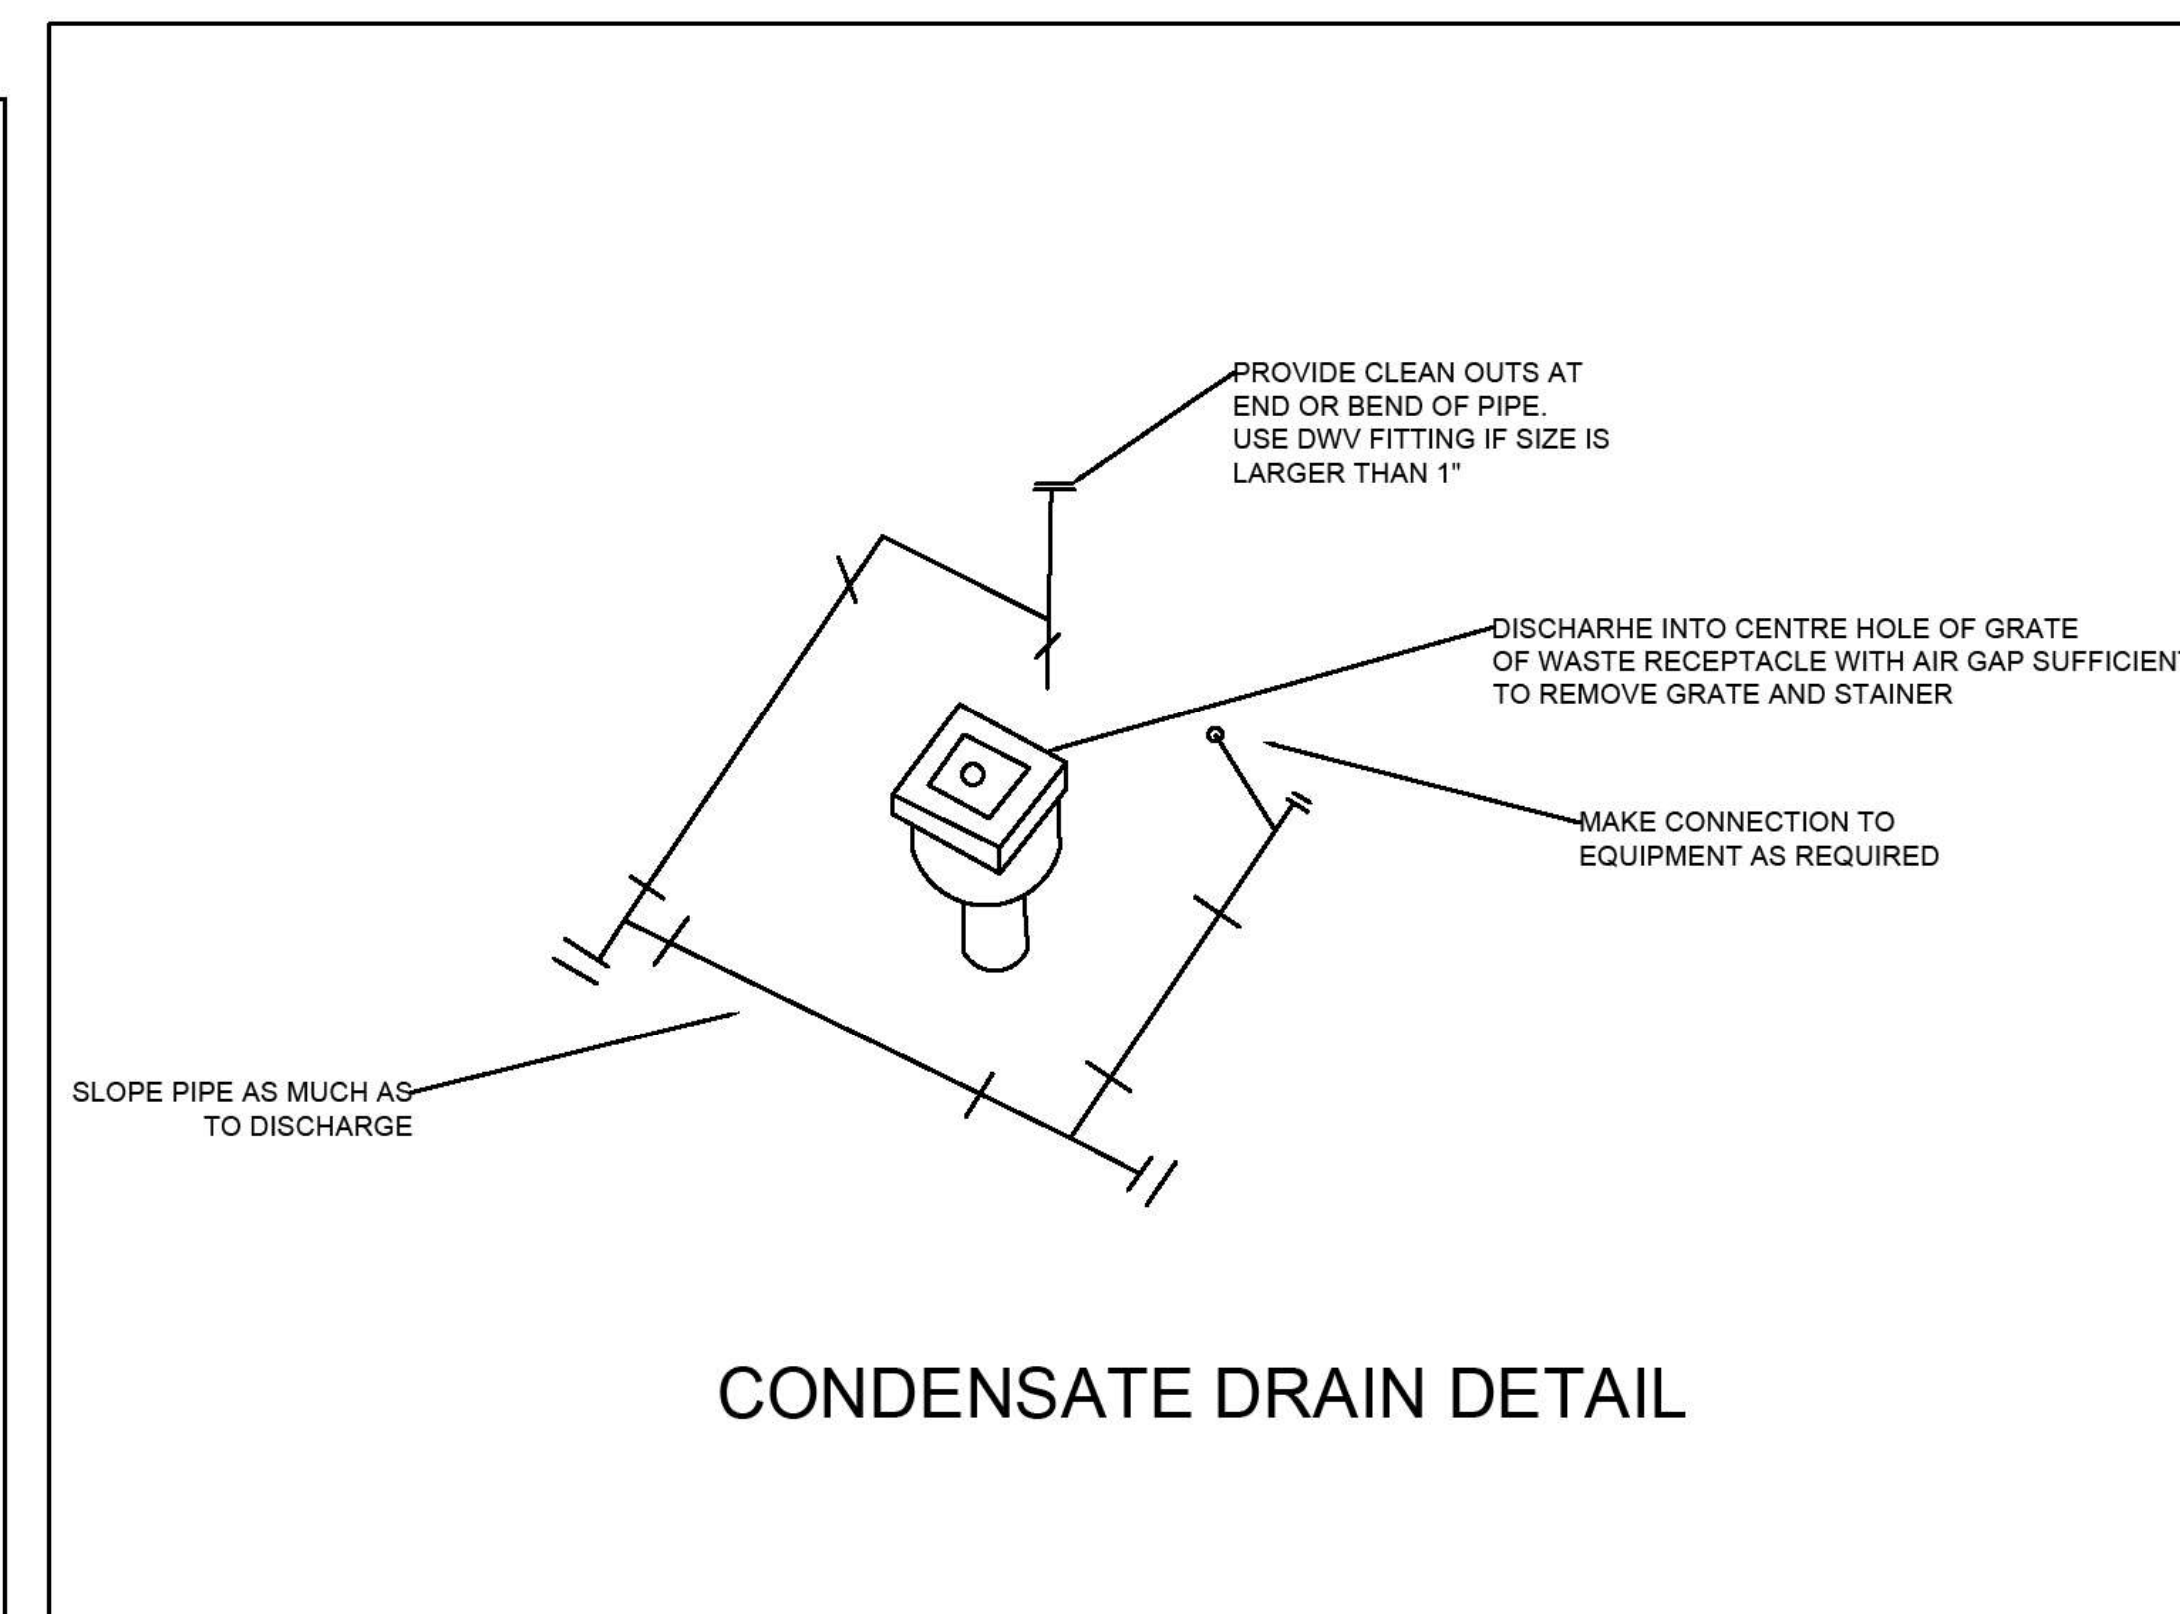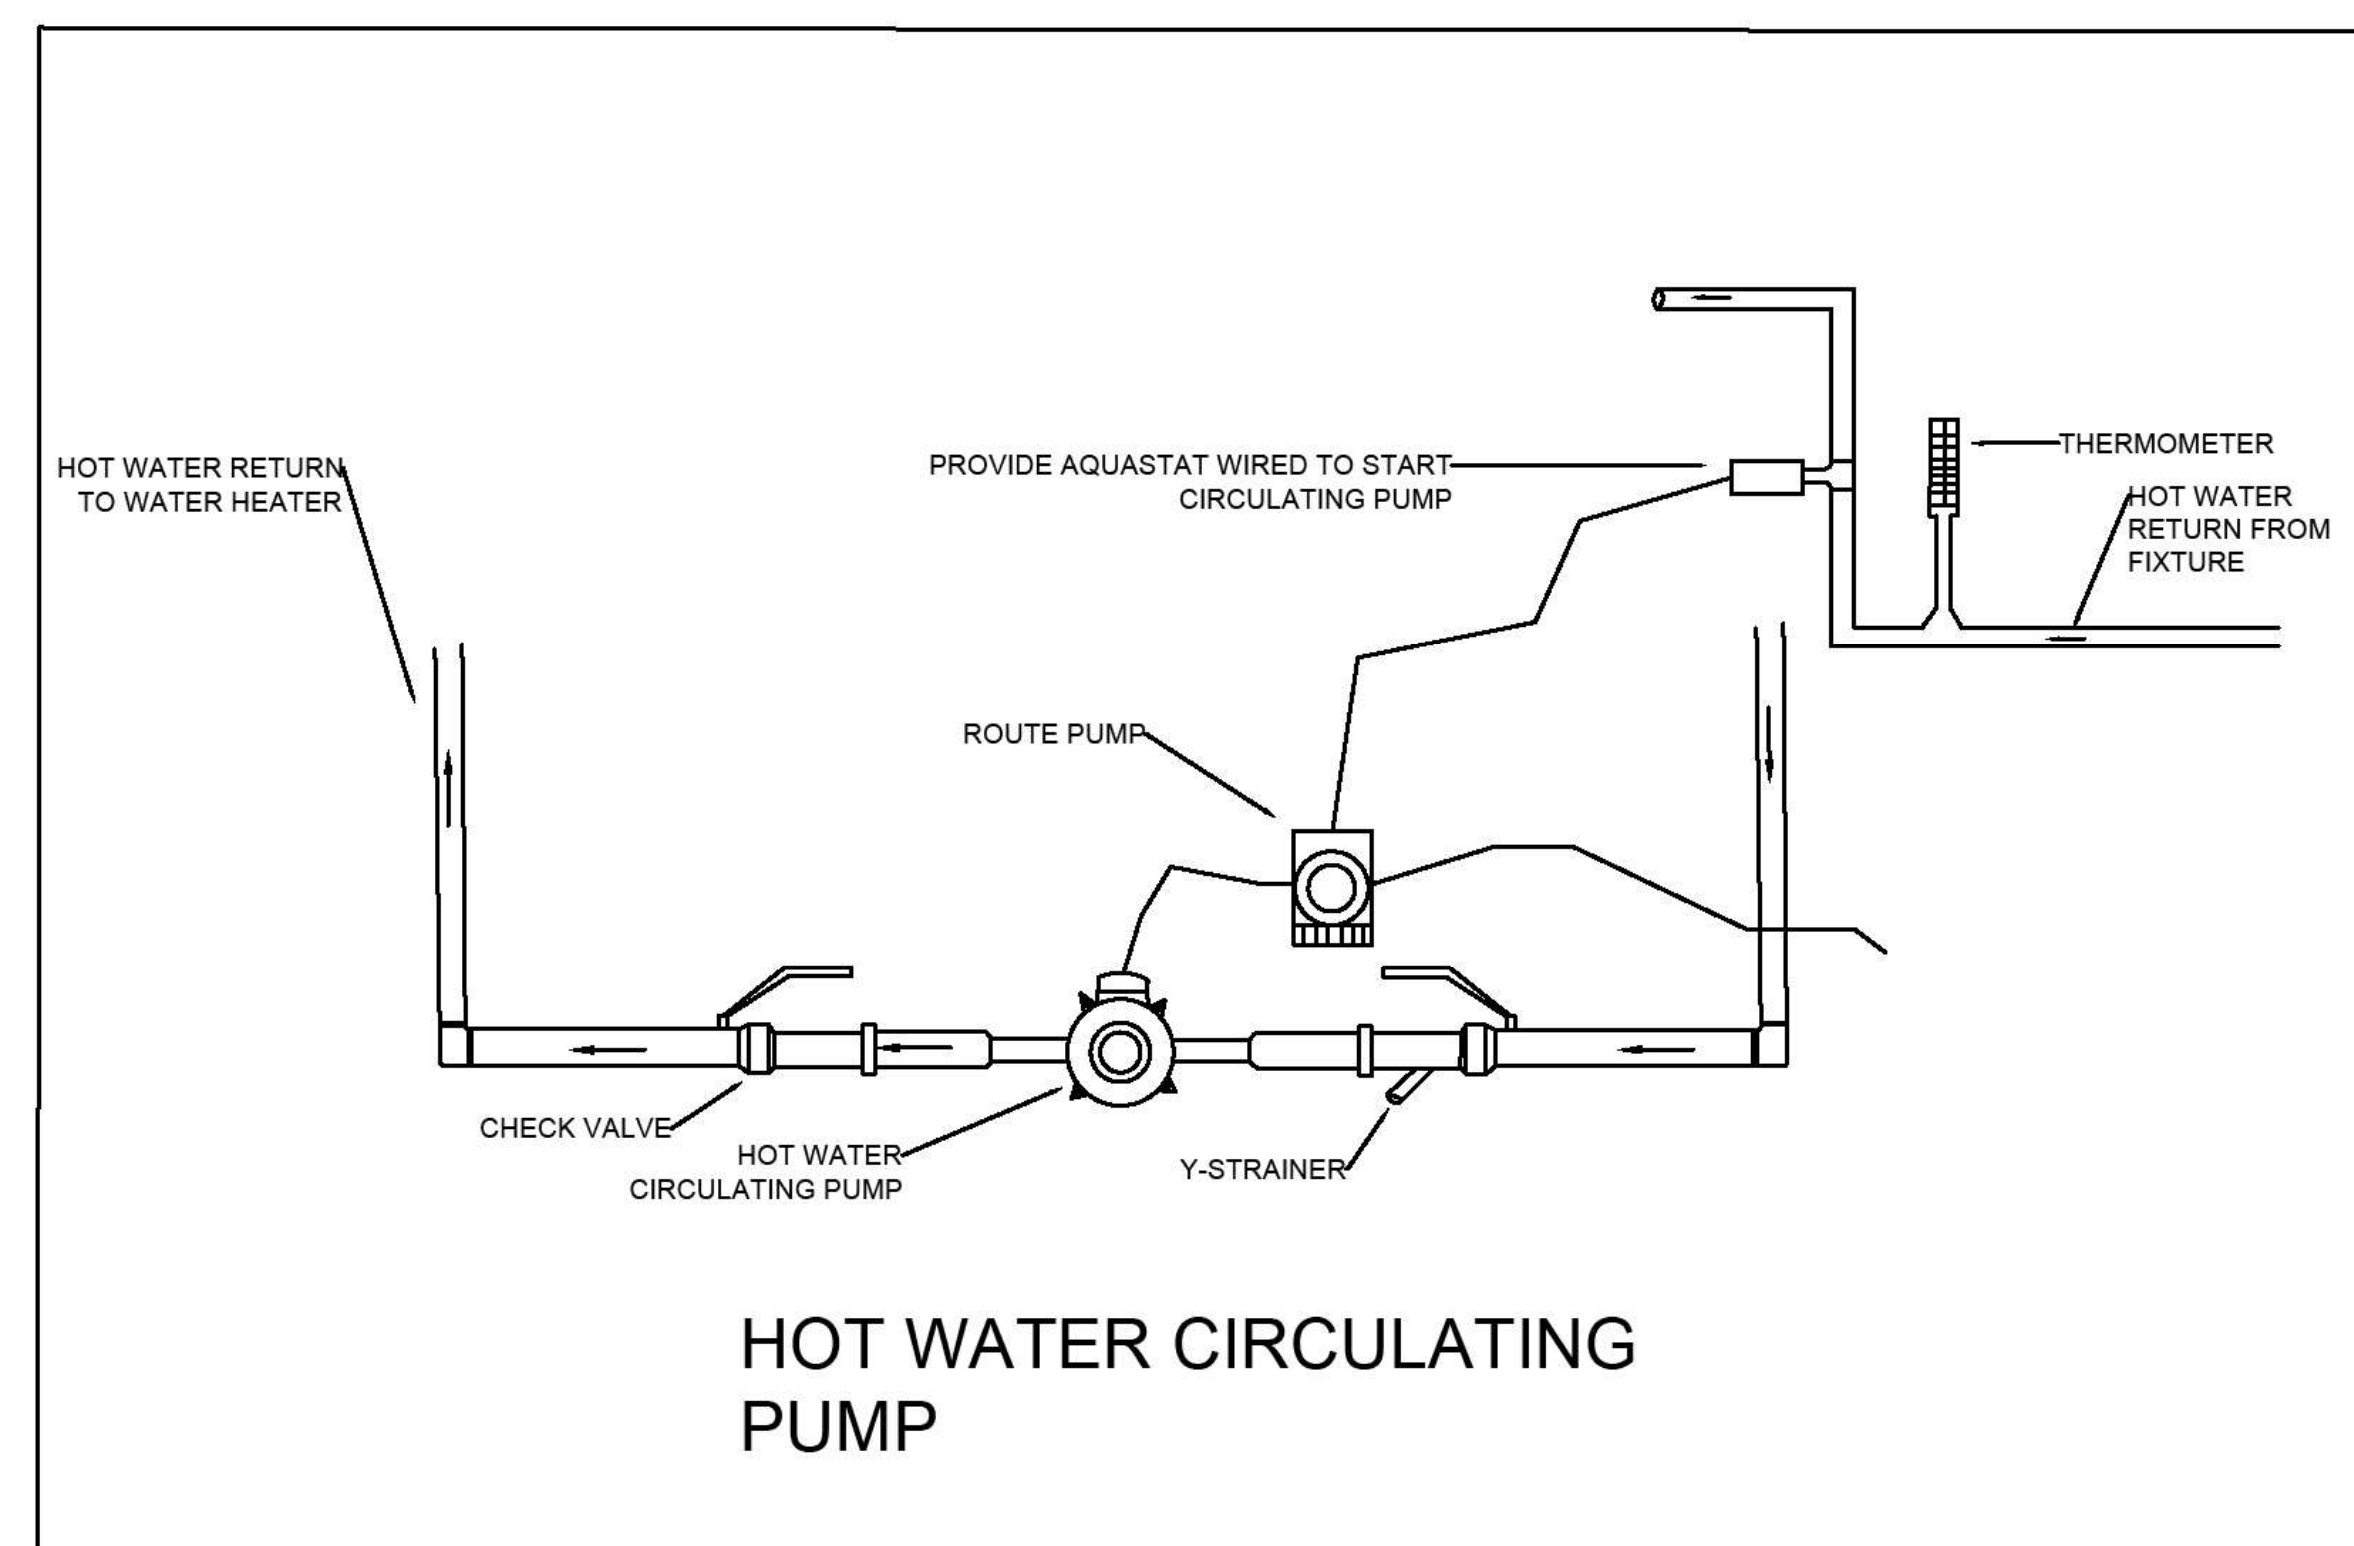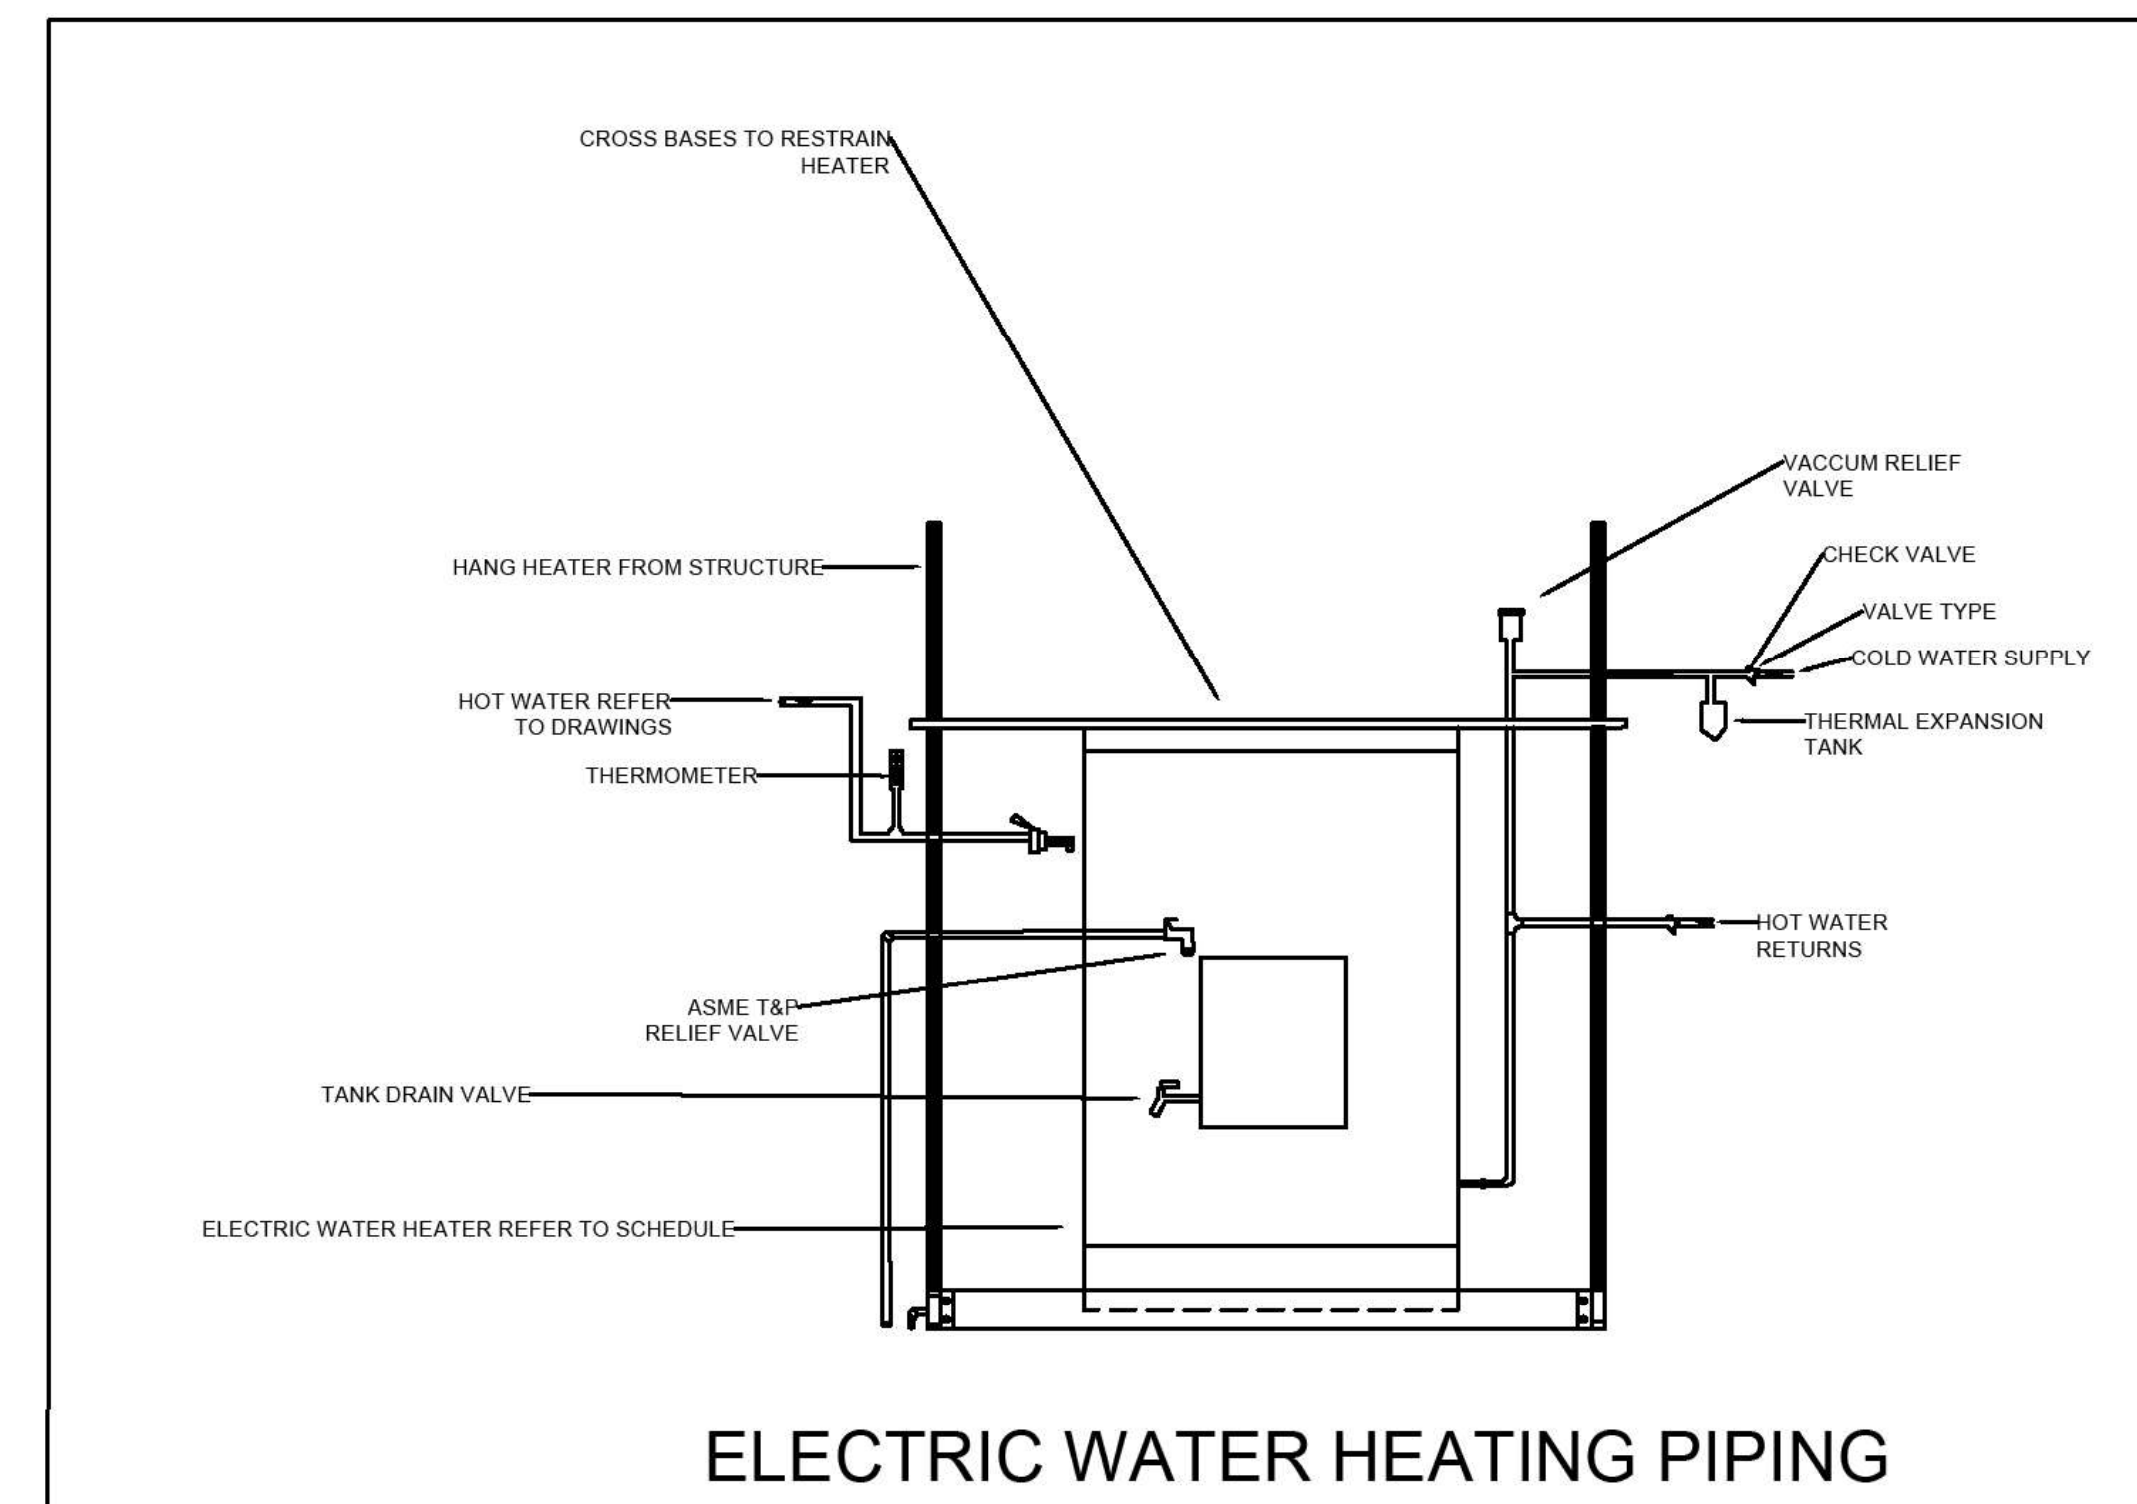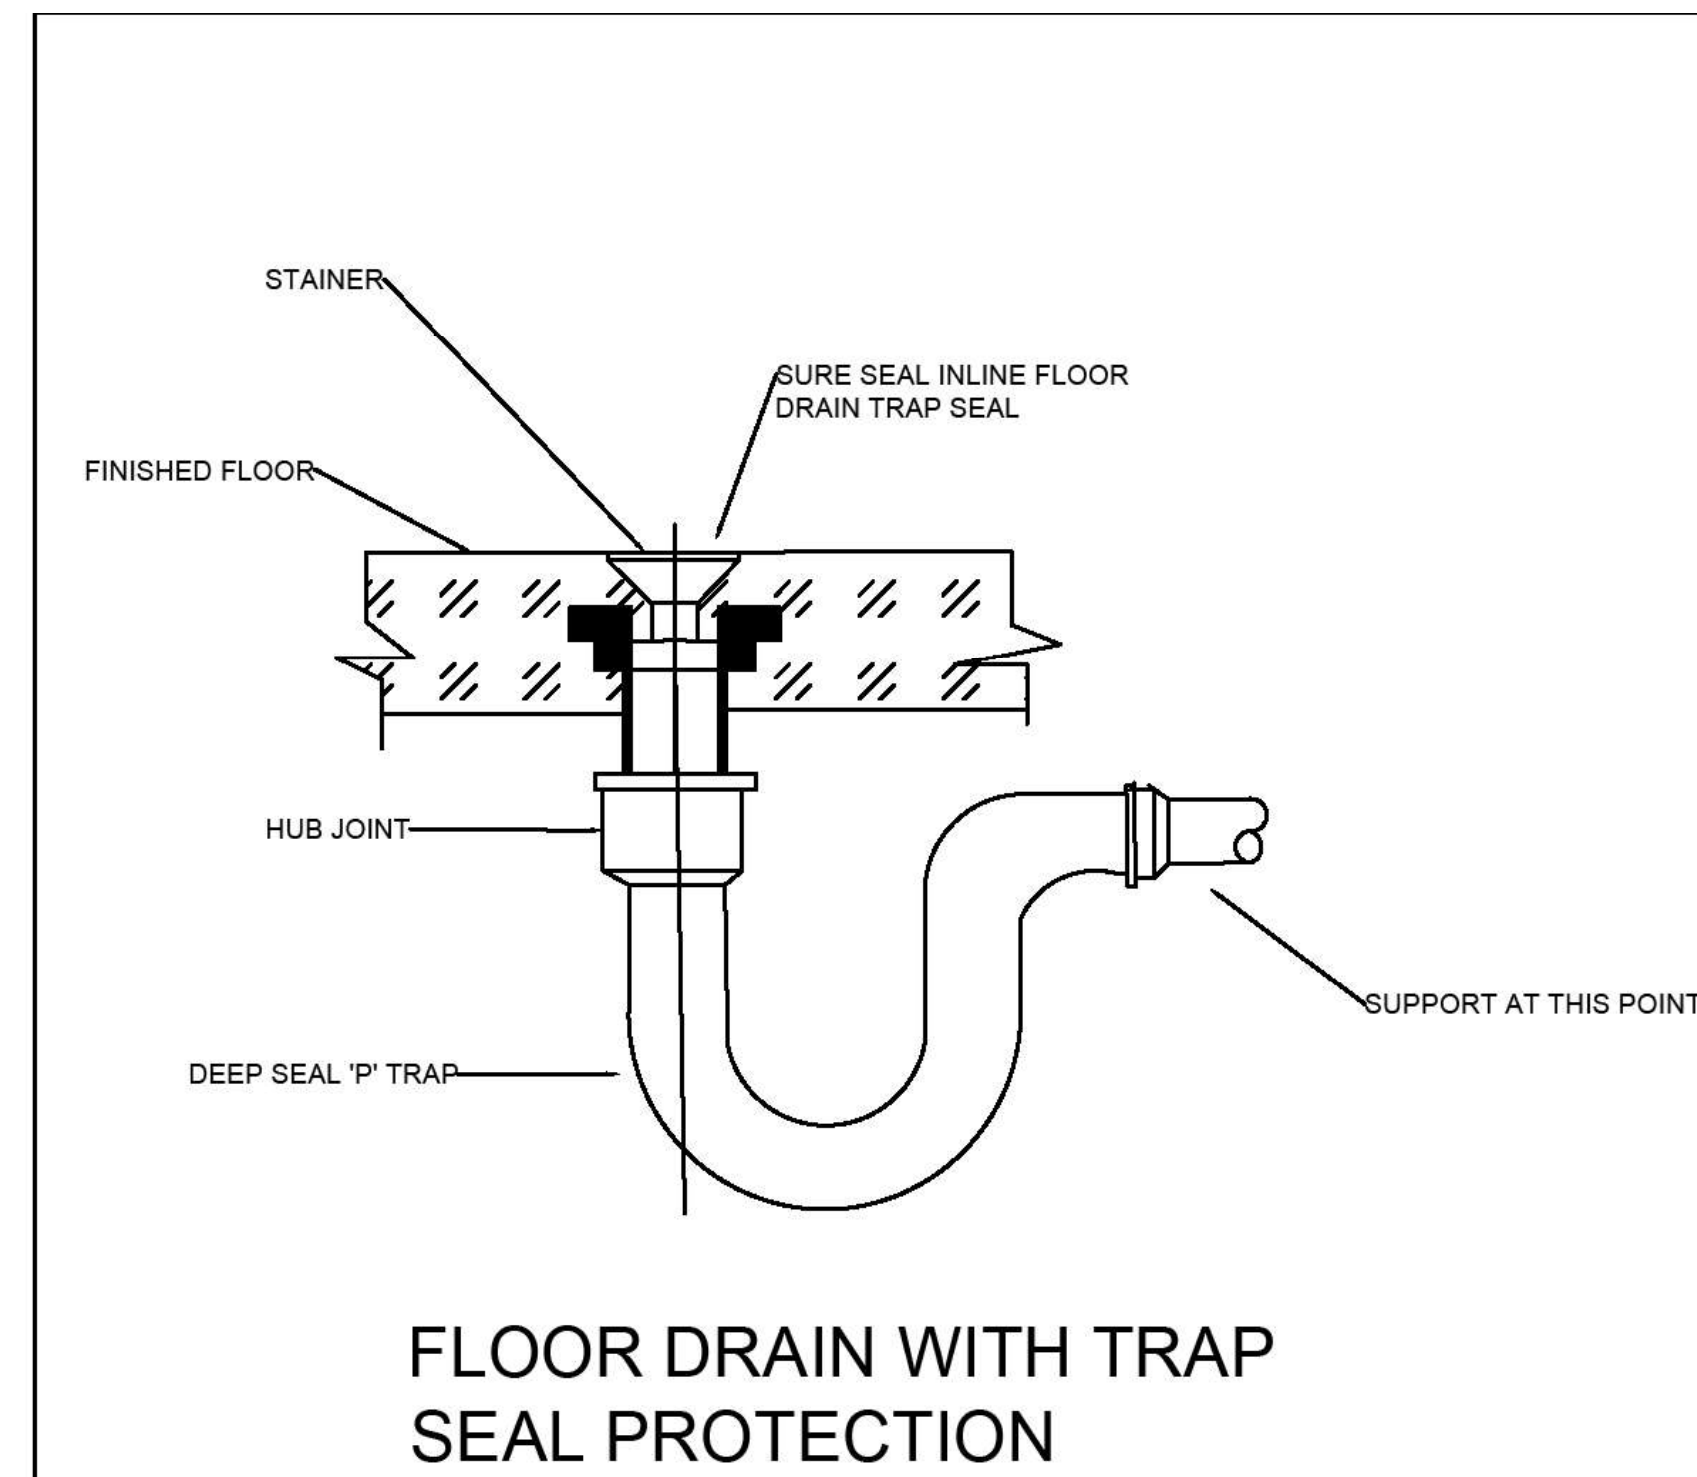

Consultant
Address
Address
Address
Phone

Consultant
Address
Address
Address
Phone

Consultant
Address
Address
Address
Phone

Consultant
Address
Address
Address
Phone

Consultant
Address
Address
Address
Phone




[illegible]

4631 Dunn Ln
Angels Camp, Ca
95222.

NEW RESIDENTIAL CONSTRUCTION

Plumbing Details

Project Number	Project Number
Date	Issue Date
Drawn By	Author
Checked By	Checker
P100B	
Scale	$1/4" = 1'-0"$

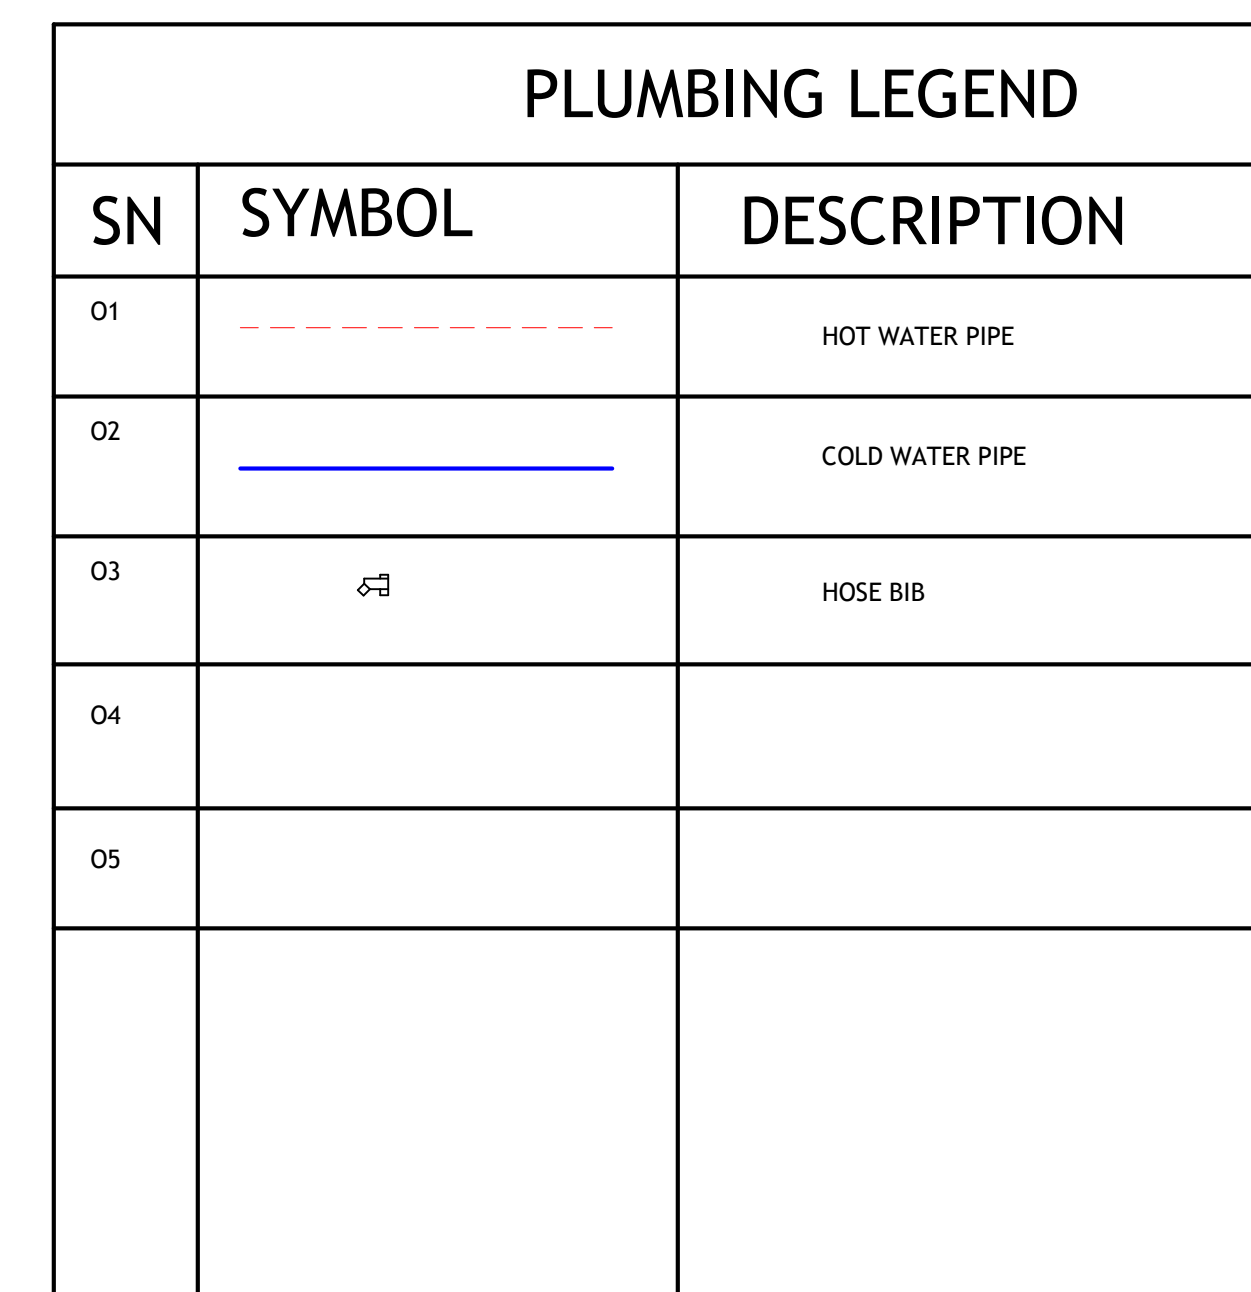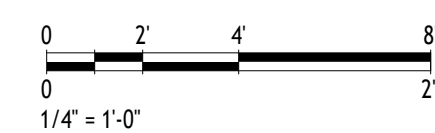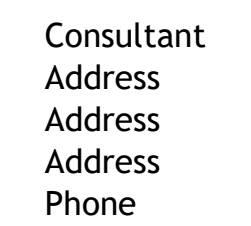[illegible]

4631 Dunn Ln
Angels Camp, Ca
95222.

NEW RESIDENTIAL CONSTRUCTION

Plumbing Plans

Project Number	Project Number
Date	Issue Date
Drawn By	Author
Checked By	Checker
P101	
Scale	1/4" = 1'-0"



Consultant
Address
Address
Address
Phone

Consultant
Address
Address
Address
Phone

Consultant
Address
Address
Address
Phone

Consultant
Address
Address
Address
Phone

Consultant
Address
Address
Address
Phone


[illegible]

4631 Dunn Ln
Angels Camp, Ca
95222.

NEW RESIDENTIAL CONSTRUCTION

Plumbing Plans

Project Number	Project Number
Date	Issue Date
Drawn By	Author
Checked By	Checker
P102	
Scale	1/4" = 1'-0"

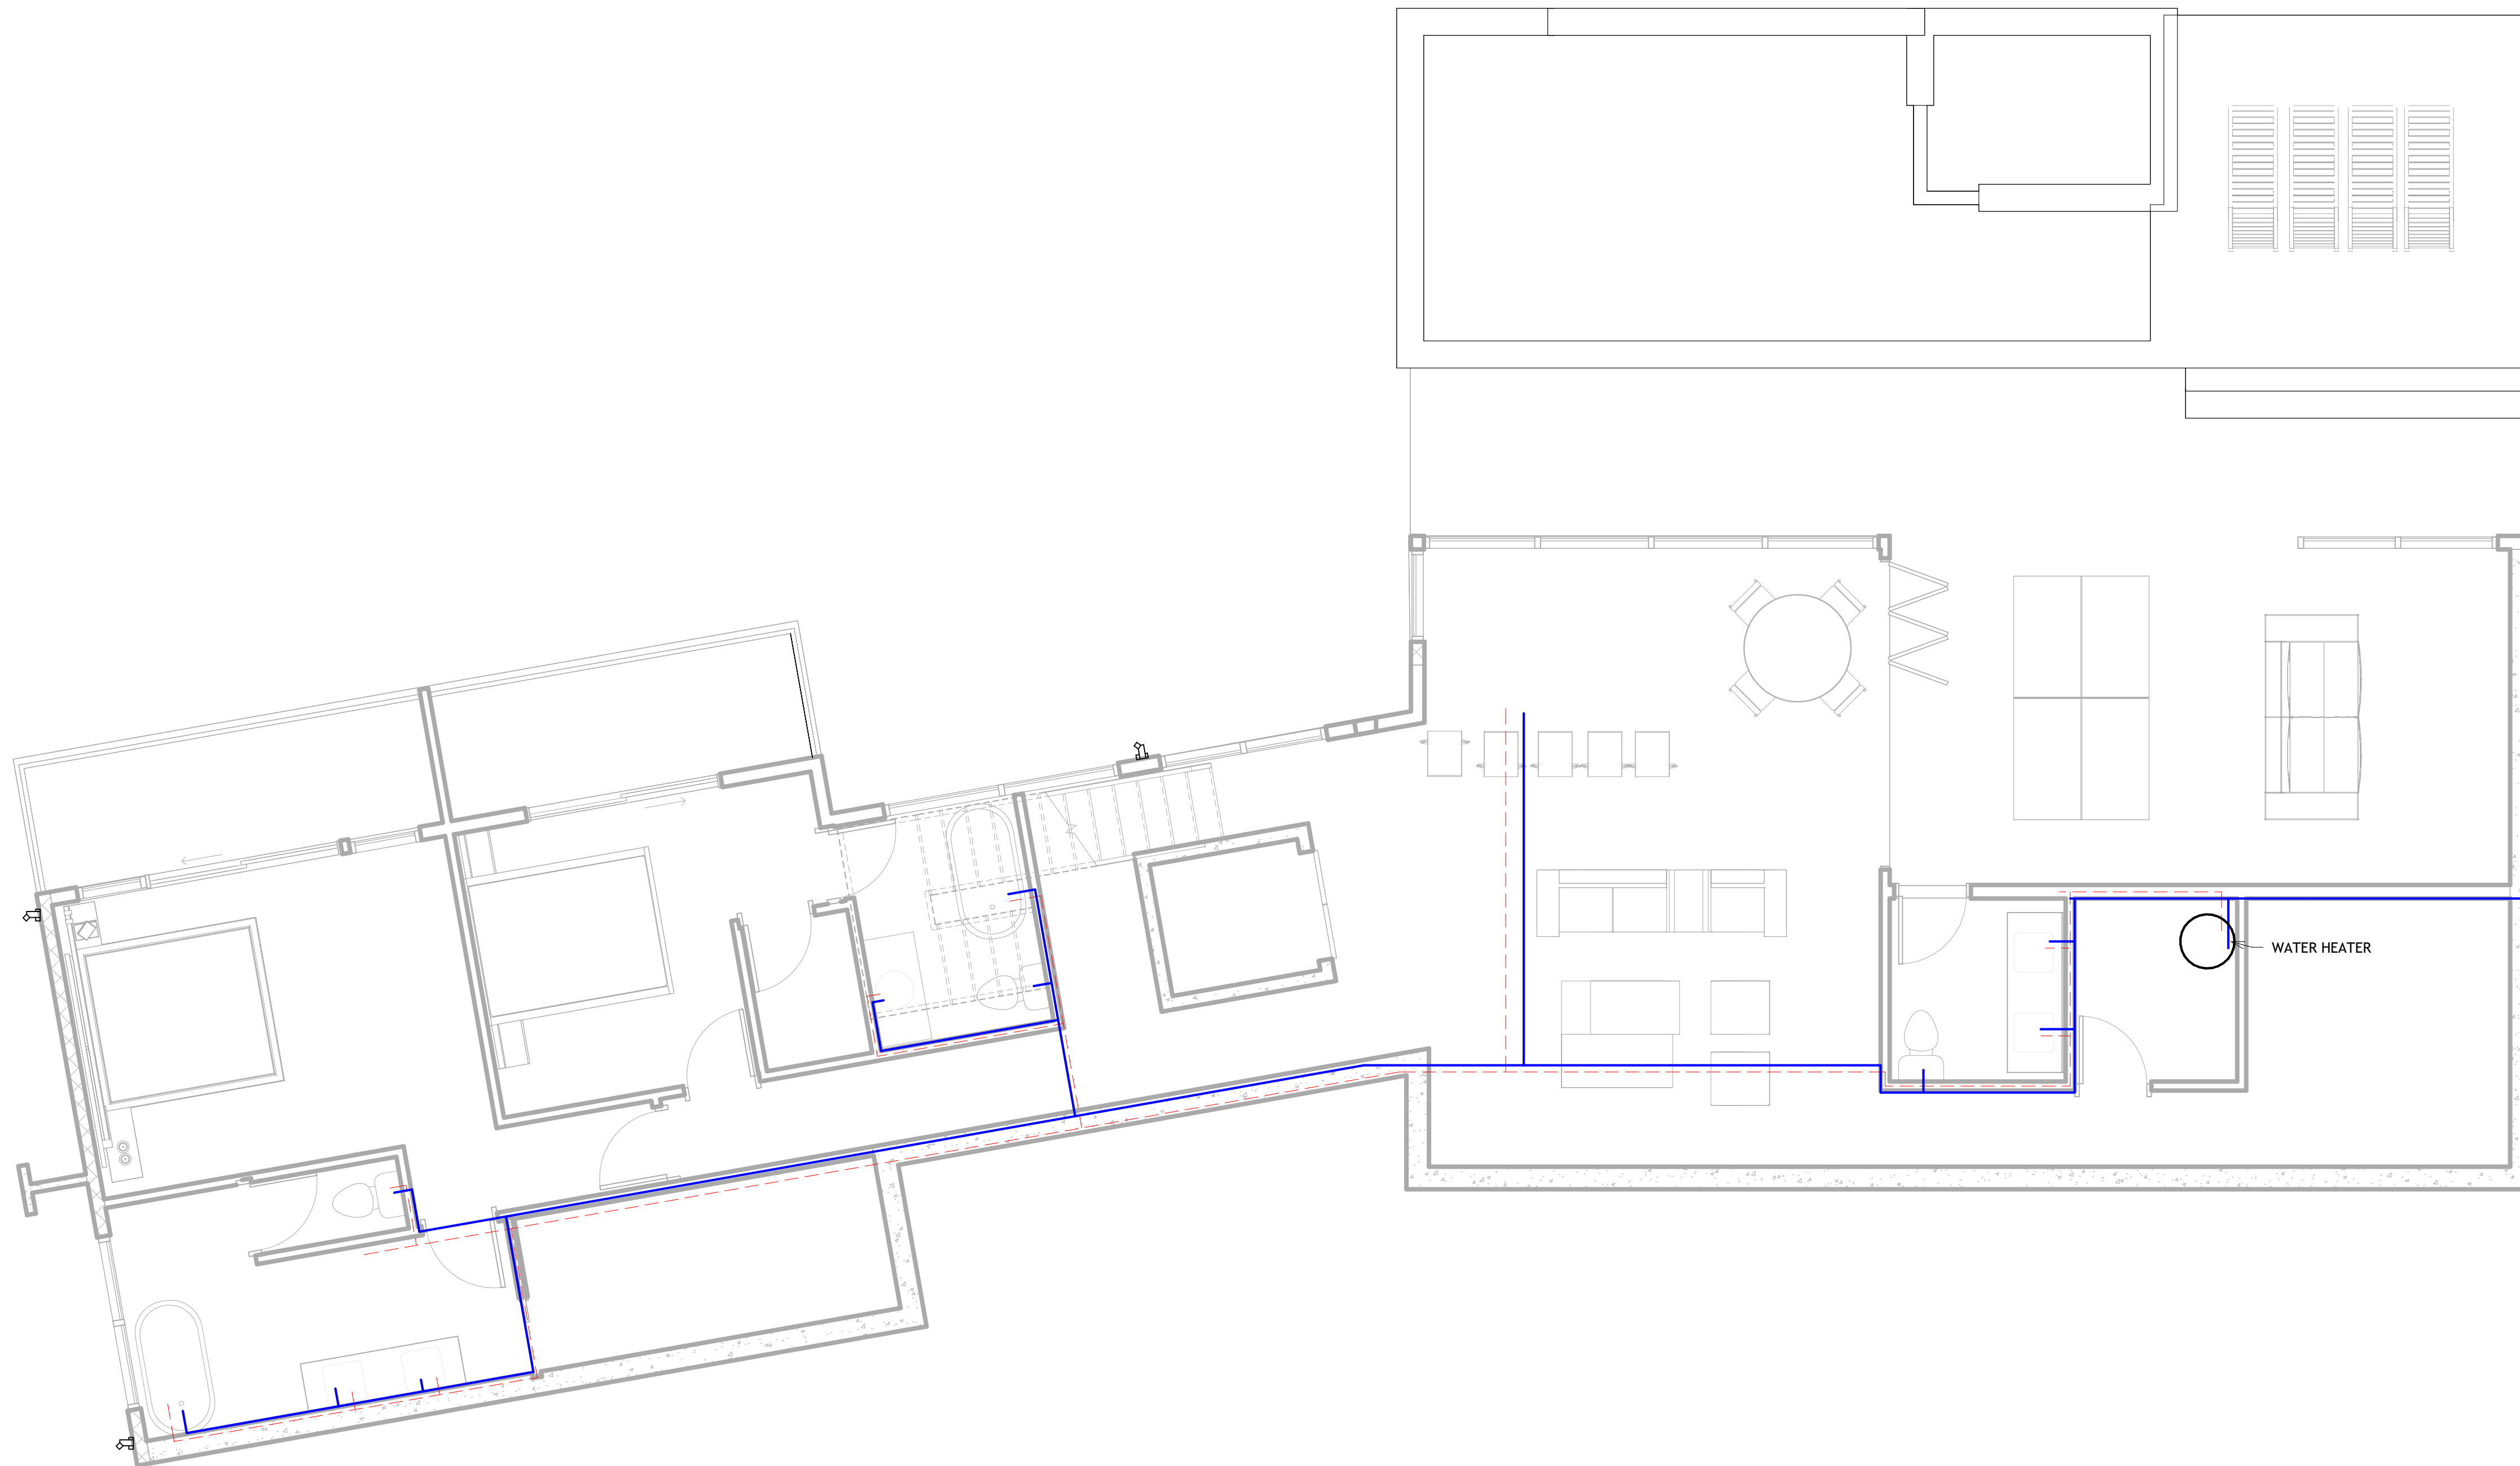

PLUMBING LEGEND		
SN	SYMBOL	DESCRIPTION
01		HOT WATER PIPE
02		COLD WATER PIPE
03		HOSE BIB
04		
05		

